


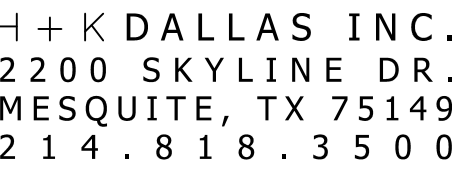

CO-OP: JOPLIN QUINCY SPRINGFIELD COL JEFF CITY



AB-1



SCALE : SEE PLAN

DESCRIPTION

TE

MRP 360
SITE PLAN LAYOUT

**2811 N KANSAS EXPWY
SPRINGFIELD, MO**

THESE DRAWINGS SPECIFICATIONS ARE THE PROPERTY
OF H+K AND SHALL NOT BE REPRODUCED OR COPIED
WITHOUT H+K'S WRITTEN PERMISSION

McDONALD'S
CORPORATION
OAK BROOK, ILLINOIS

13526

240453

SHEET #

2 OF 11

S H E E T :

AB-2



1 MAIN SIGNAGE

1 MAIN SIGNAGE

2 ENTRANCE SIG

3 LIGHT POLES

4 EXTERIOR SEAT

5 PLAYPLACE

6 FLAG POLE

7 MAIN ENTR

8 SIDE ENTRY




9 DRIVE THRU ORDER POINT

10 EXTERIOR TRASH

11 EXTERIOR SERVICES

12 EXIT SIGN

	PROPERTY LINE
	LANDSCAPE PERIMETER LINE
	BUILDING PERIMETER LINE
	PARKING AND OBJECT LINE
	GRASS
	BUILDING

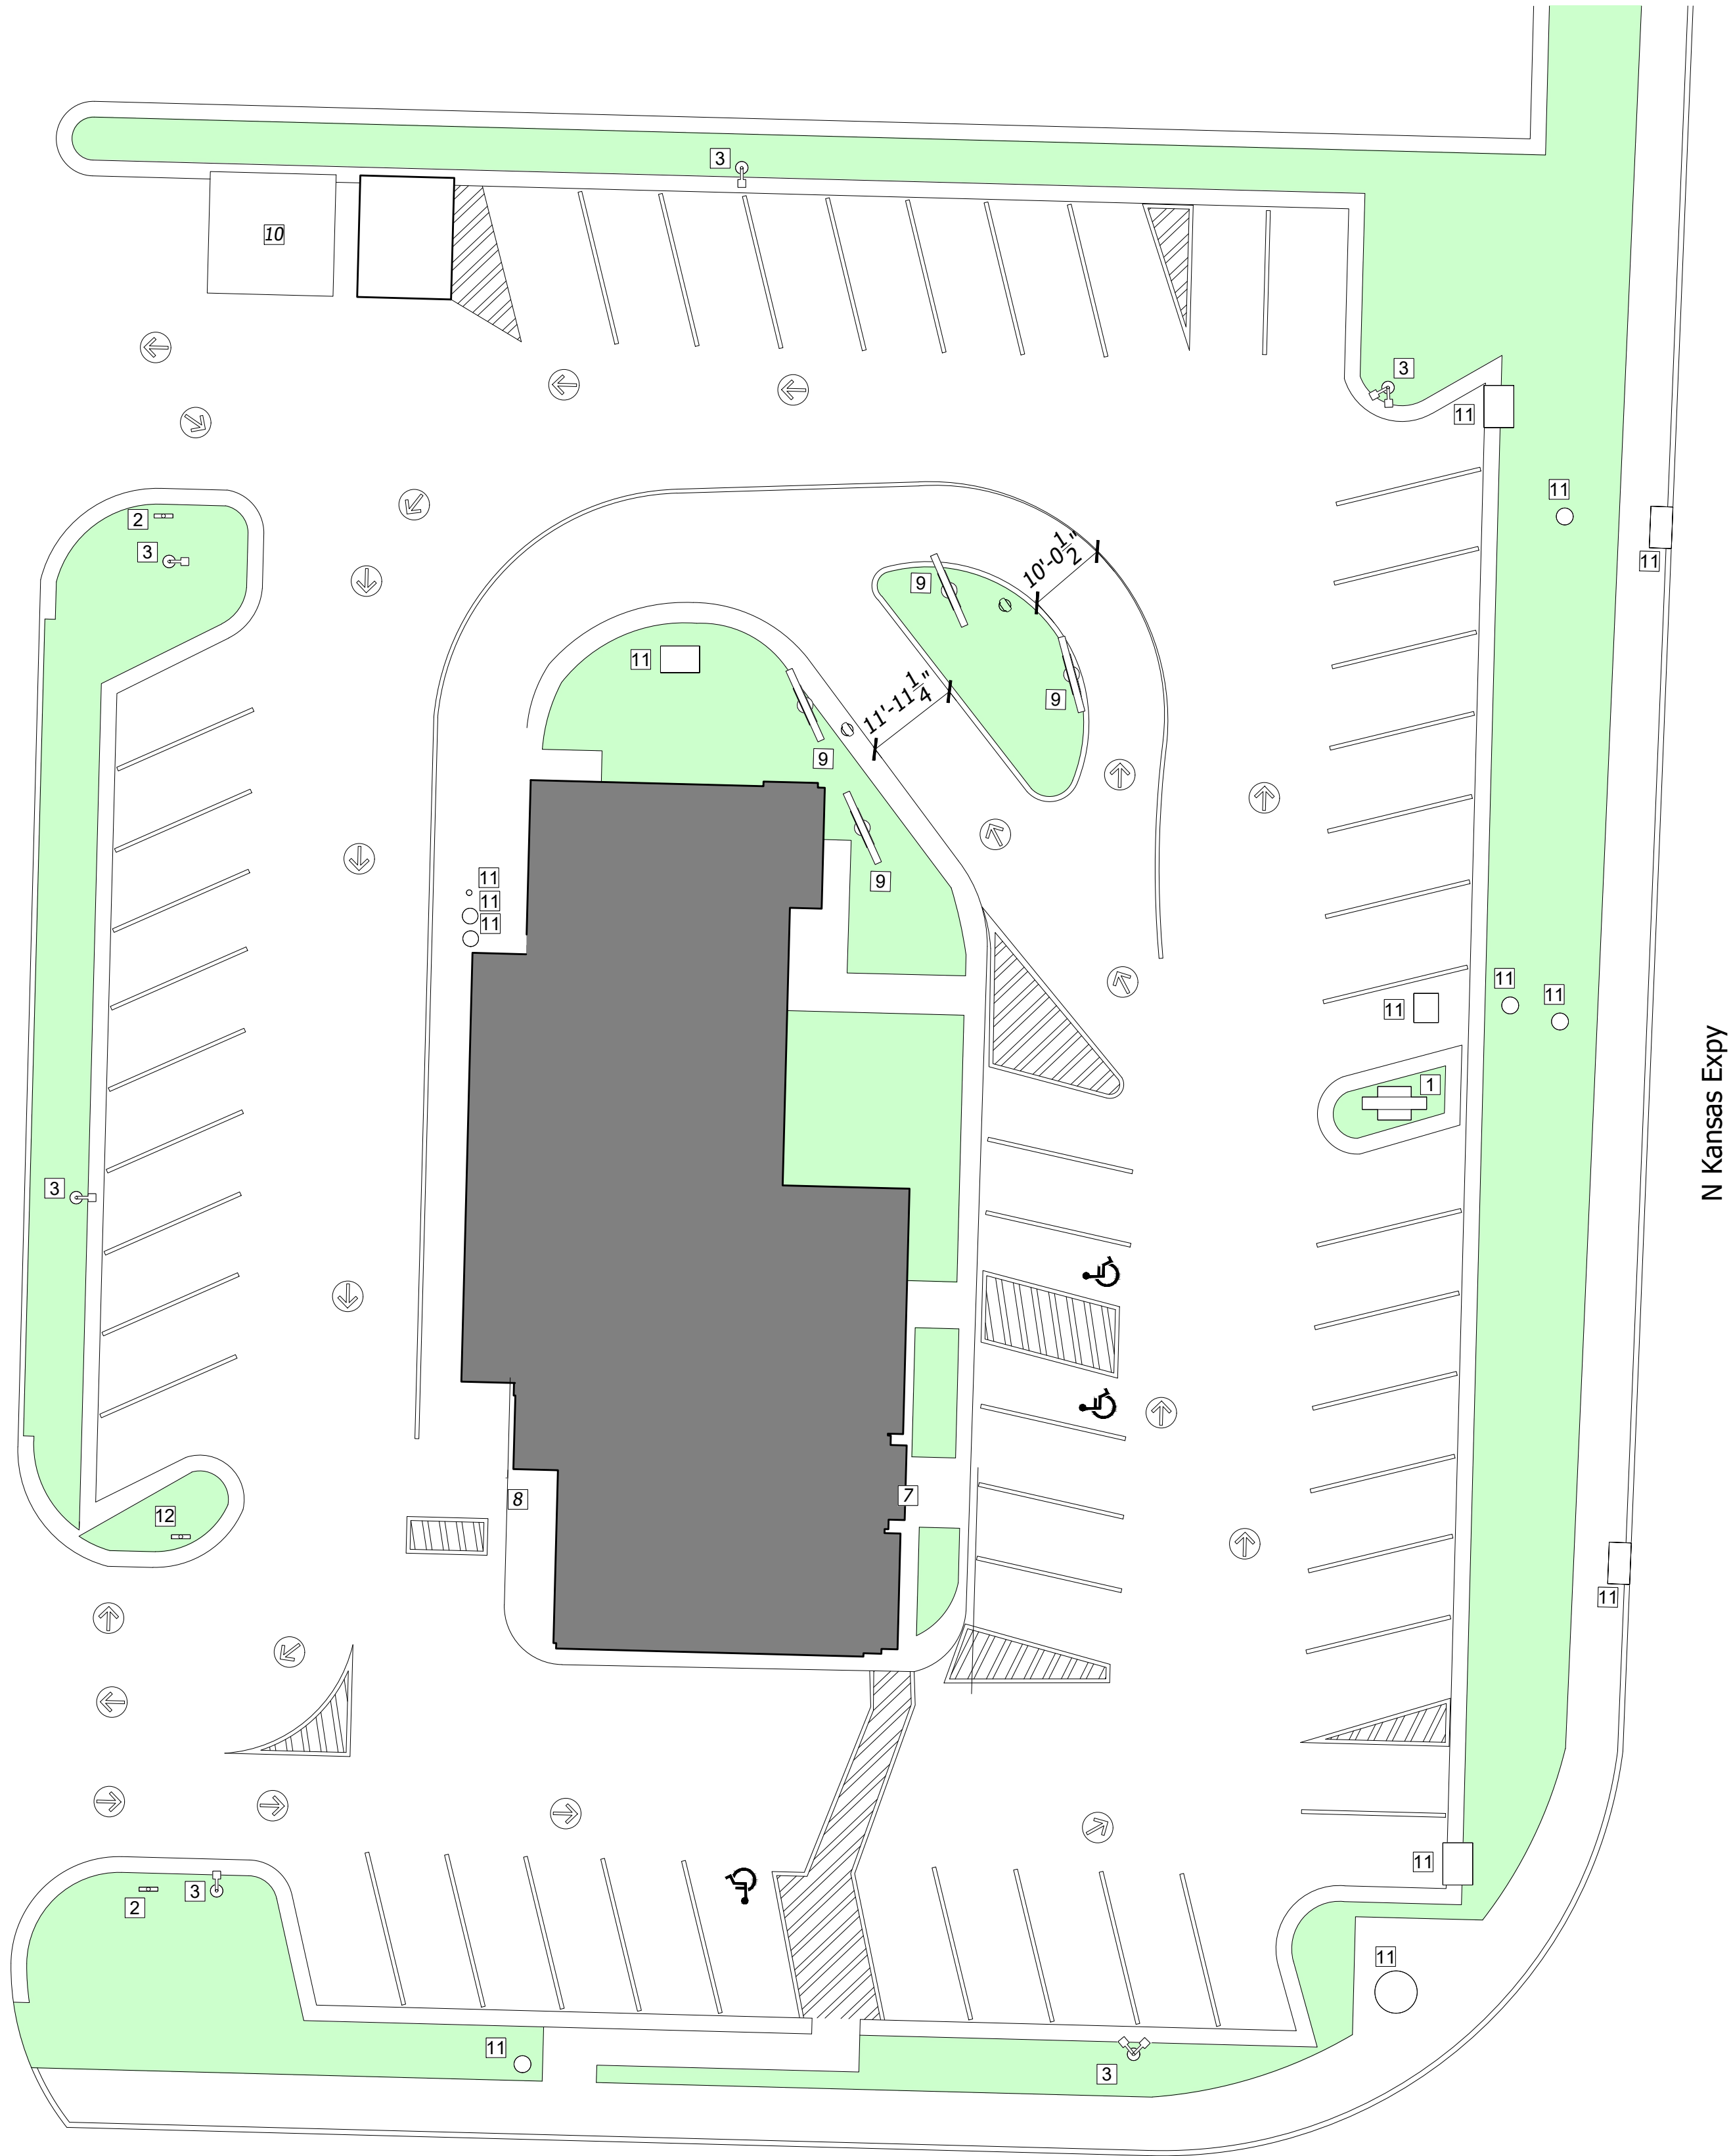  

DATE : 25APR22

DRAWN : EC

CHECKED: ☐ OPEN: ☐

SCALE : SEE PLAN

 γ

DESCRIPTION

 ∇ $\mathbb{R}$

W

T I T L E :

MRP 360

EQUIPMENT PLAN LAYOUT

**2811 N KANSAS EXPWY
SPRINGFIELD, MO**

THESE DRAWINGS SPECIFICATIONS ARE THE PROPERTY
OF H+K AND SHALL NOT BE REPRODUCED OR COPIED
WITHOUT H+K'S WRITTEN PERMISSION

**McDONALD'S
CORPORATION**
OAK BROOK, ILLINOIS

STORE # :

13526

SITE ID:


240453

SHEET #

4 OF 11


S H E E T :

AB-4

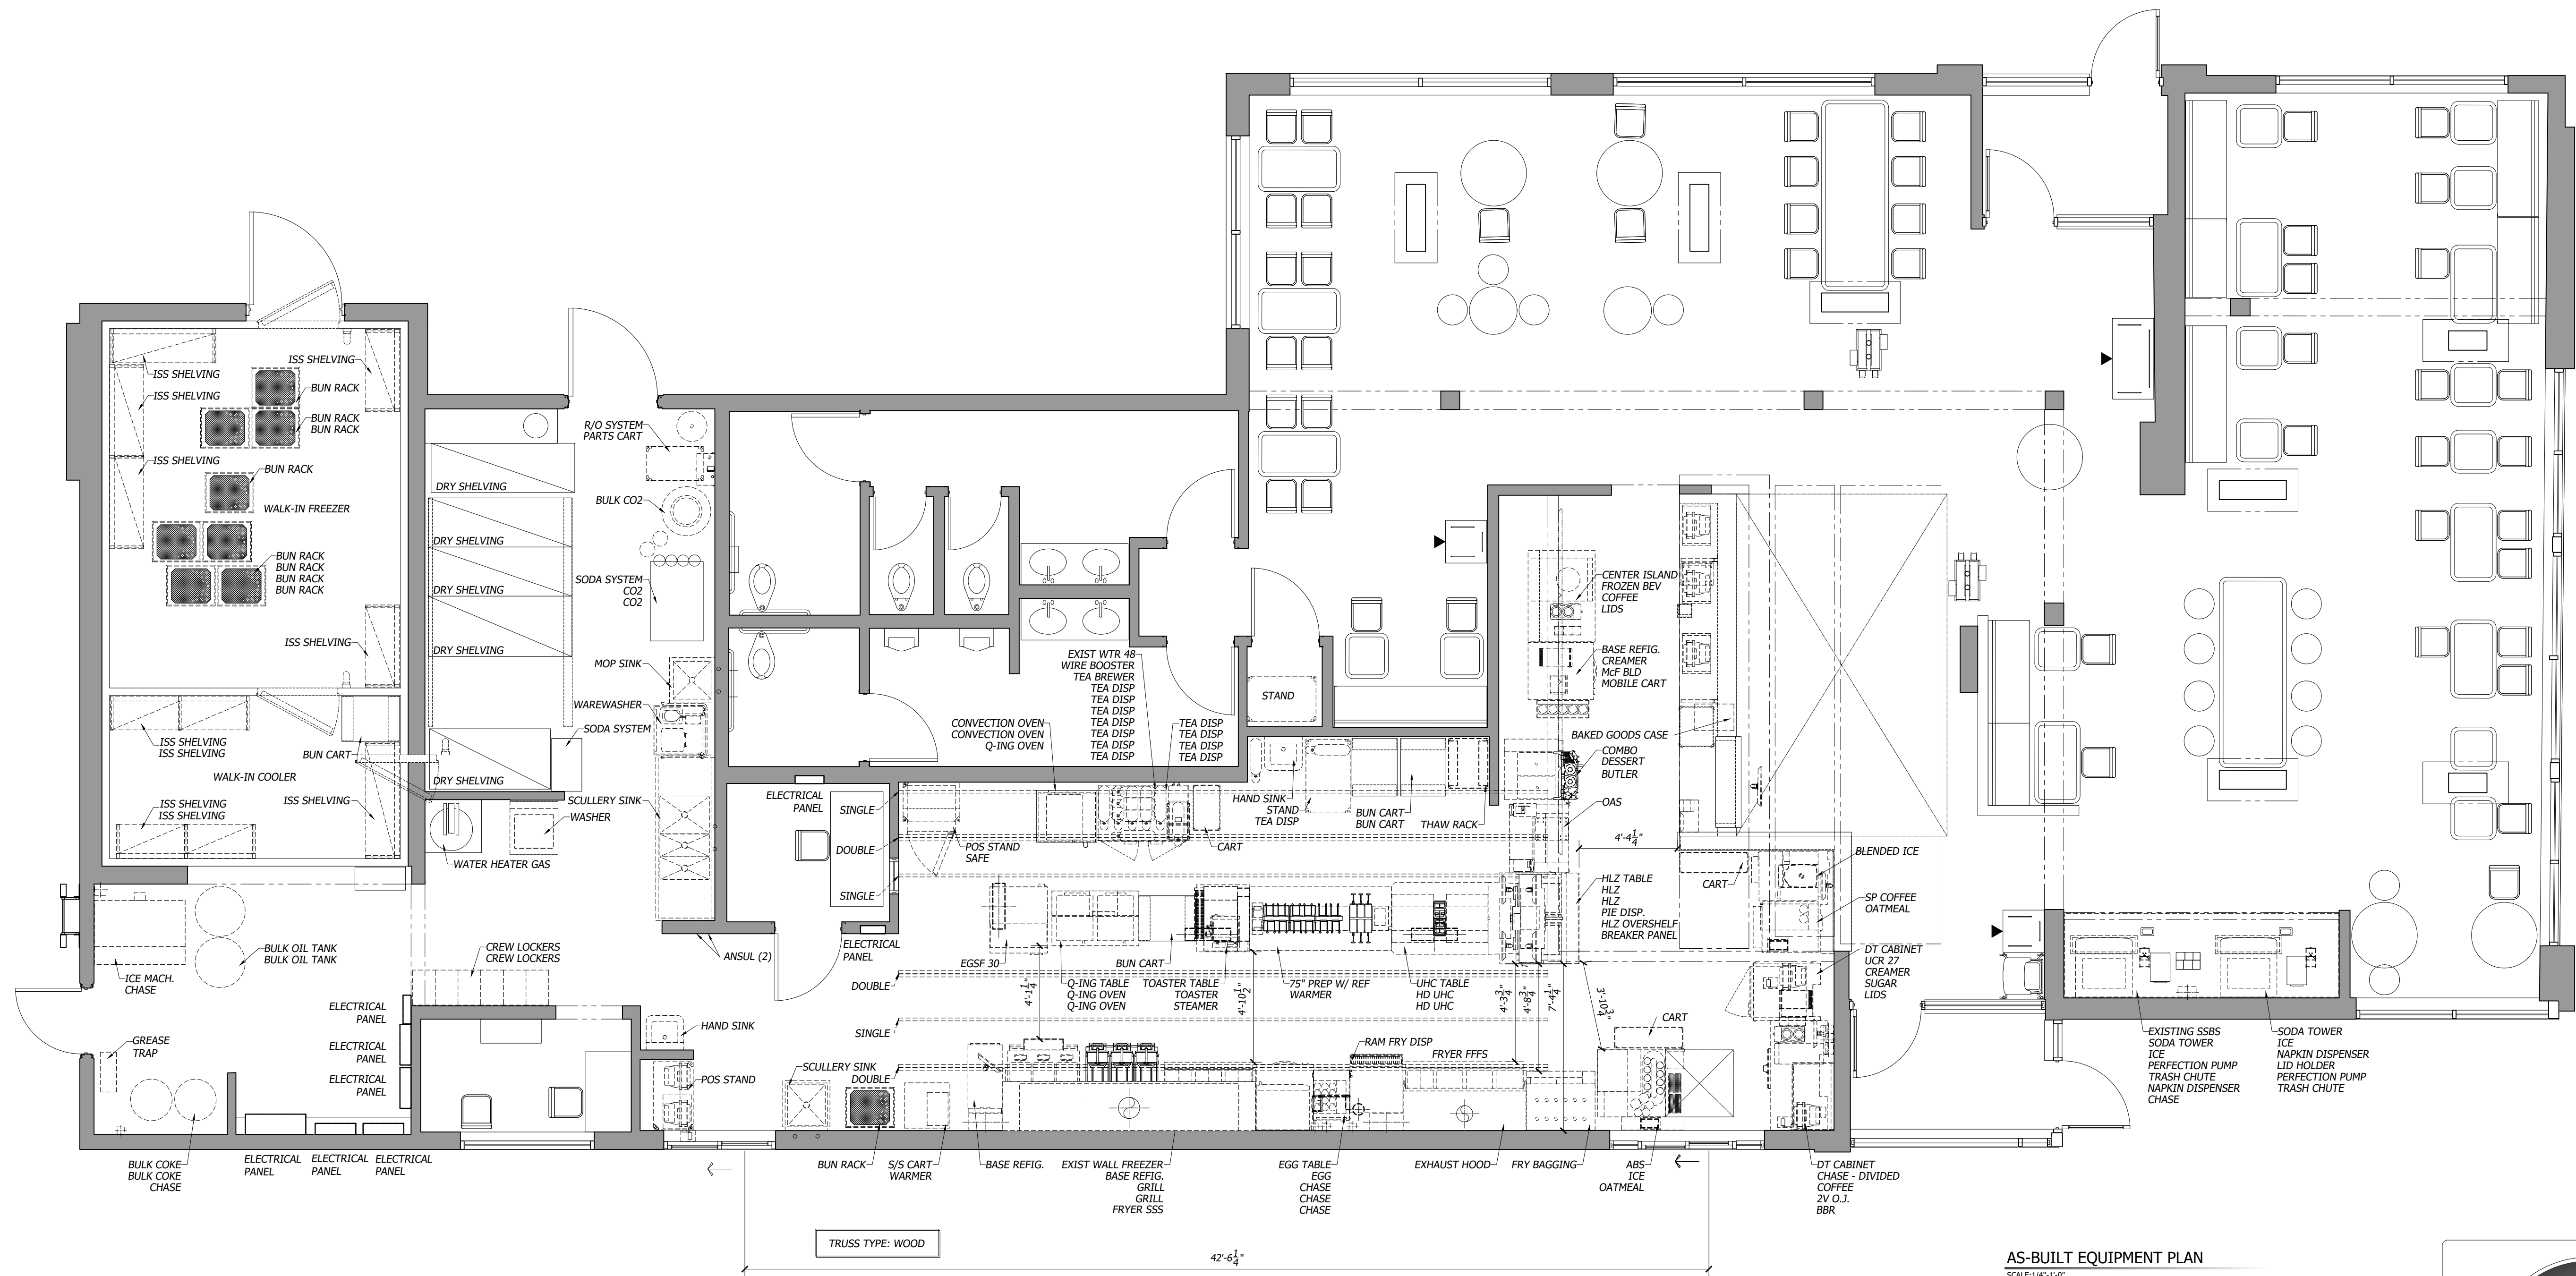

AS-BUILT EQUIPMENT PLAN

SCALE: 1/4"=1'-0"

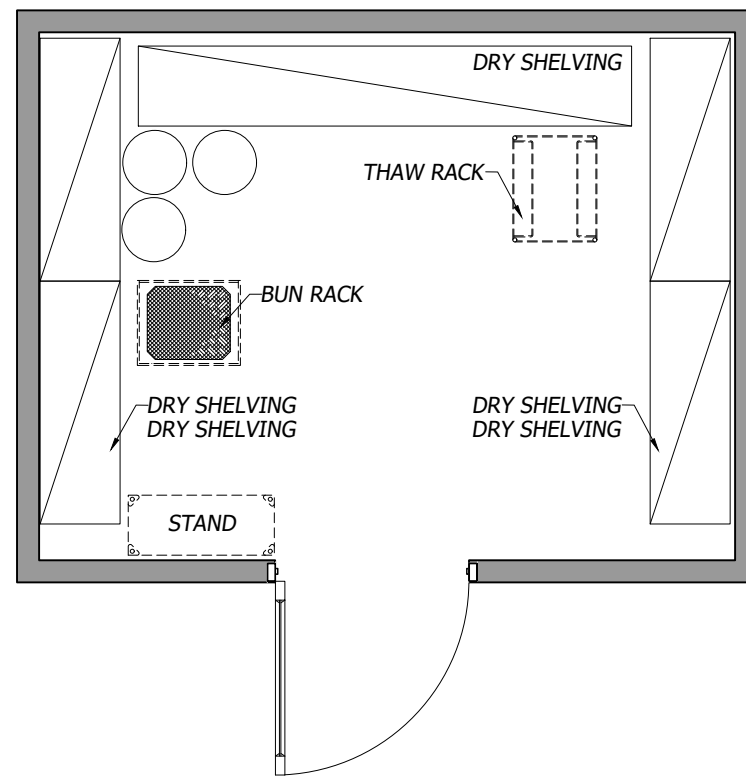

[3D VIRTUAL TOUR LINK](#)
(PDF DRAWING VERSION ONLY)
CLICK TO VIEW THE 360 VIRTUAL WALKTHROUGH



3D VIRTUAL TOUR LINK
SCAN QR CODE TO VIEW 360 VIRTUAL WALKTHROUGH

LEGEND

- EXISTING EQUIPMENT
 ----- EXISTING TRUSSES
 _____ SERVICE AREA
 ----- OVERHEAD
 [Shaded Box] EXISTING FULL WALL
 _____ EXISTING LOW WALL



H + K DALLAS INC.
2200 SKYLINE DR.
MESQUITE, TX 75149
214.818.3500

DATE : 25APR22

D R A W N : EC

CHECKED: OP

SCALE : SEE PLAN

[illegible]

T I T L E :

MRP 360
REFLECTED CEILING PLAN

**2811 N KANSAS EXPWY
SPRINGFIELD, MO**

THESE DRAWINGS SPECIFICATIONS ARE THE PROPERTY
OF H+K AND SHALL NOT BE REPRODUCED OR COPIED
WITHOUT H+K'S WRITTEN PERMISSION

C U S T O M E R :

McDONALD'S
CORPORATION
OAK BROOK, ILLINOIS

STORE # :

13526

240453

SHEET #

5 OF 11

S H E E T :

 
AB-5



AS-BUILT REFLECTED CEILING PLAN
SCALE: 1/4"=1'-0"



CLICK TO VIEW THE 360 VIRTUAL WALKTHROUGH



3D VIRTUAL TOUR LINK
SCAN QR CODE TO VIEW 360 VIRTUAL WALKTHROUGH

LEGEND

- EXISTING EQUIPMENT
 ----- EXISTING TRUSSES
 _____ SERVICE AREA
 ----- OVERHEAD
 [Shaded Box] EXISTING FULL WALL
 _____ EXISTING LOW WALL



H + K INTERNATIONAL

H + K DALLAS INC.
2200 SKYLINE DR.
MESQUITE, TX 75149
214.818.3500

DATE : 25APR22

DRAWN : EC

CHECKED : OP

SCALE : SEE PLAN

BY						
DESCRIPTION						
REV						
DATE						

TITLE :

MRP 360
ELEVATIONS LAYOUT

2811 N KANSAS EXPWY
SPRINGFIELD, MO

THESE DRAWINGS SPECIFICATIONS ARE THE PROPERTY
OF H+K AND SHALL NOT BE REPRODUCED OR COPIED
WITHOUT H+K'S WRITTEN PERMISSION

CUSTOMER :

MCDONALD'S
CORPORATION
OAK BROOK, ILLINOIS

STORE # :

13526

SITE ID :


240453

SHEET #


6 OF 11

SHEET :


AB-6

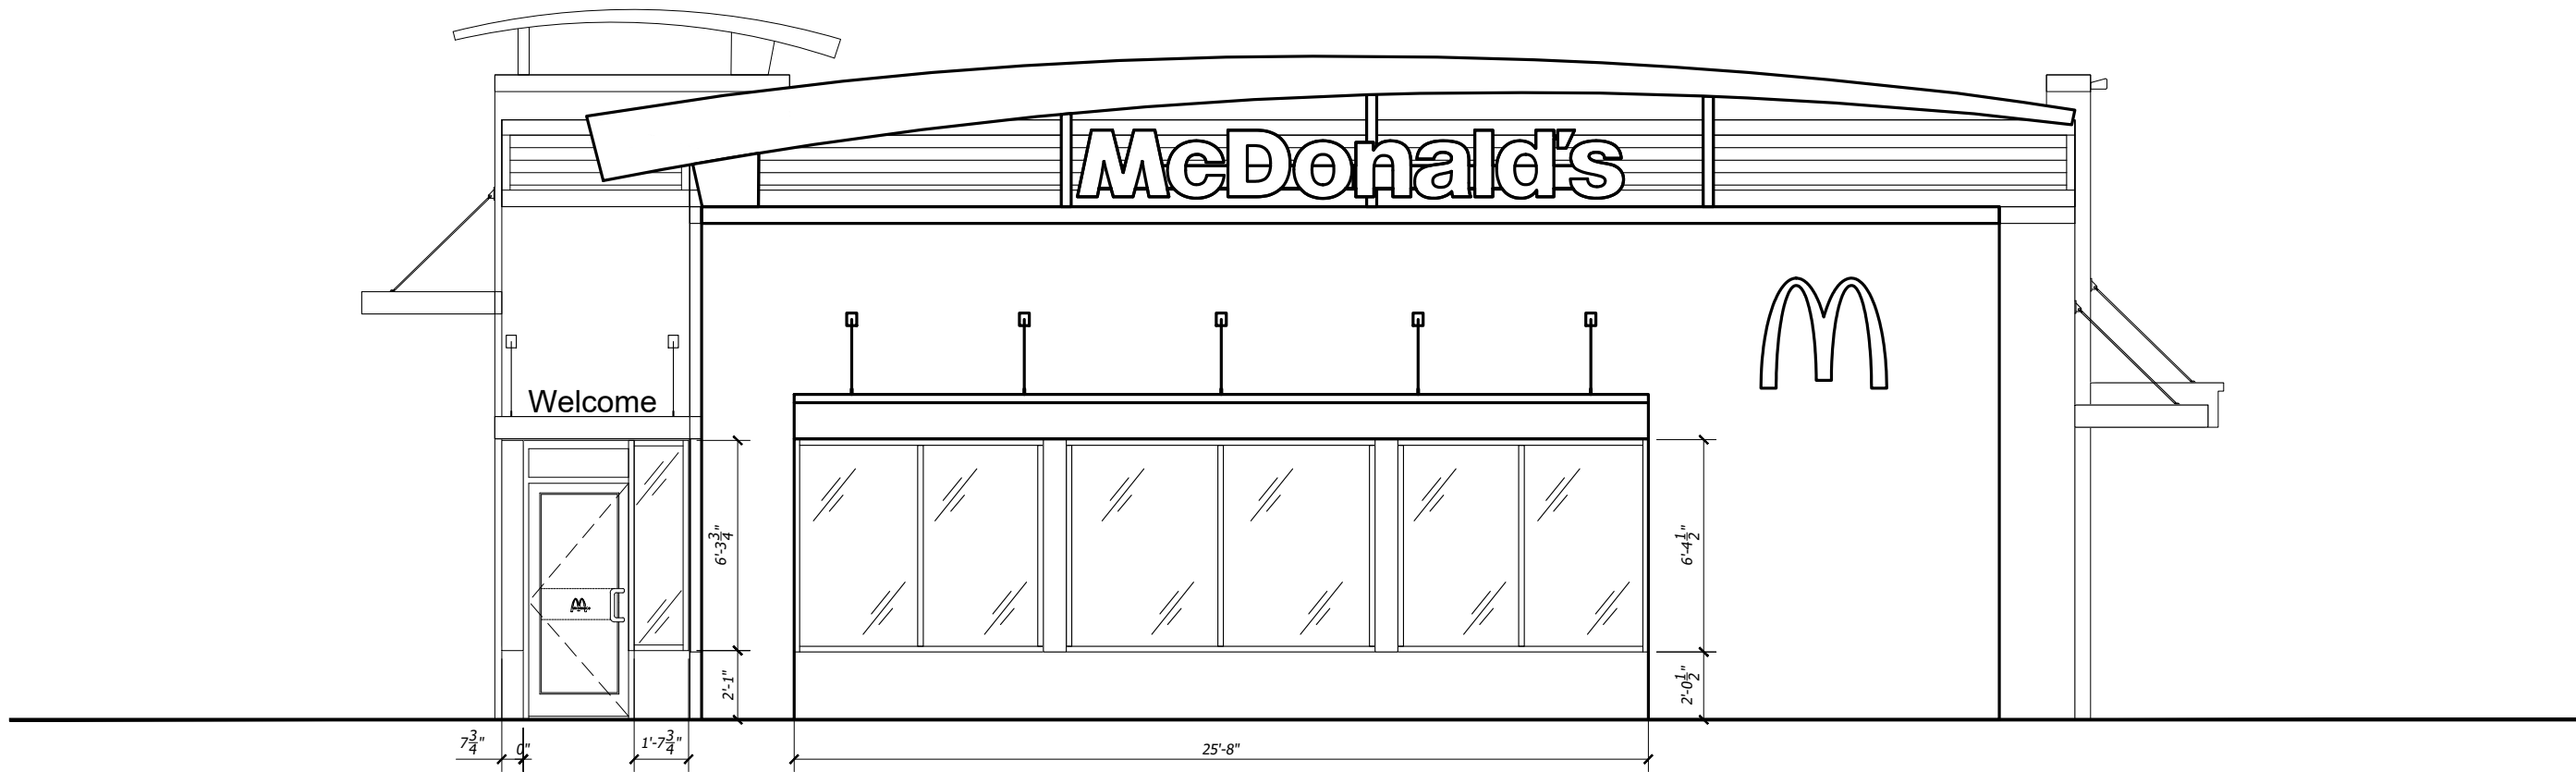


FRONT ELEVATION
SCALE : 3/16" = 1'

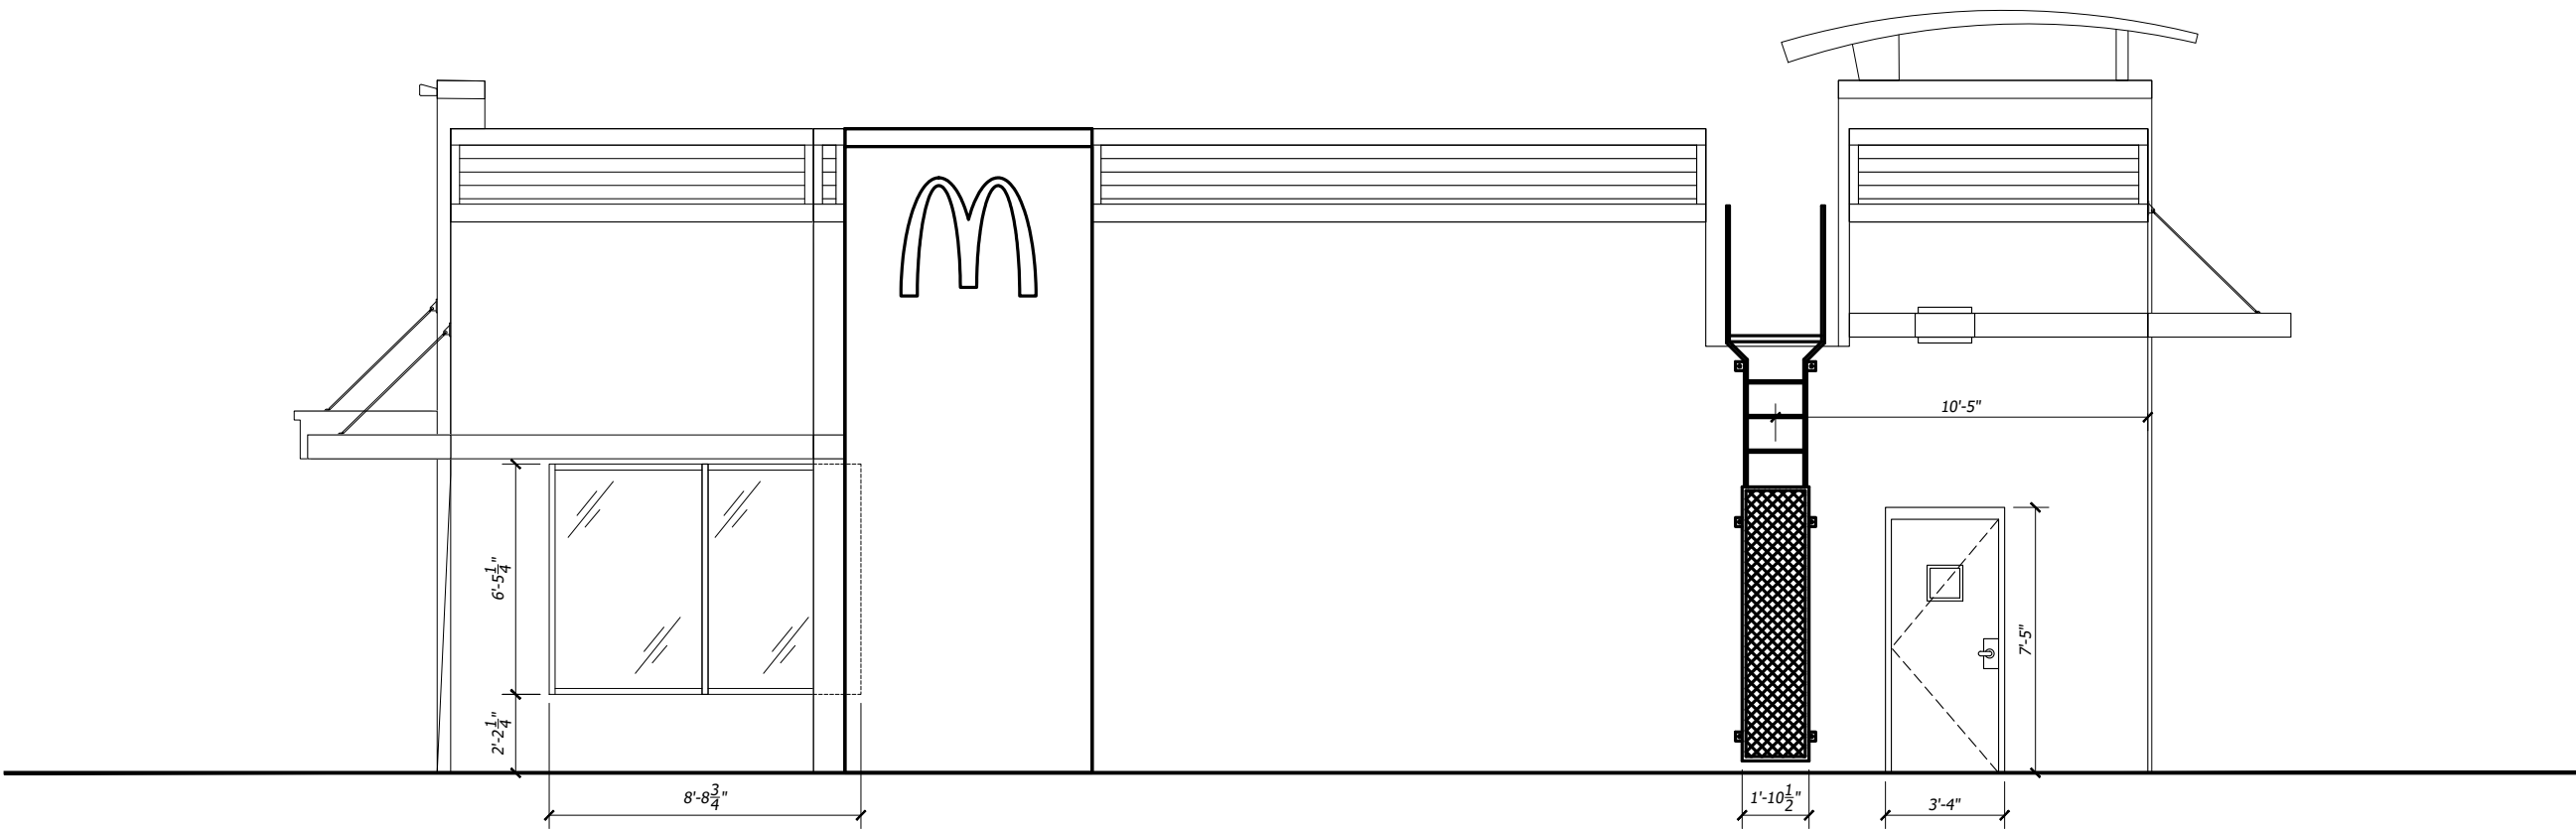

BACK ELEVATION
SCALE : 3/16" = 1'

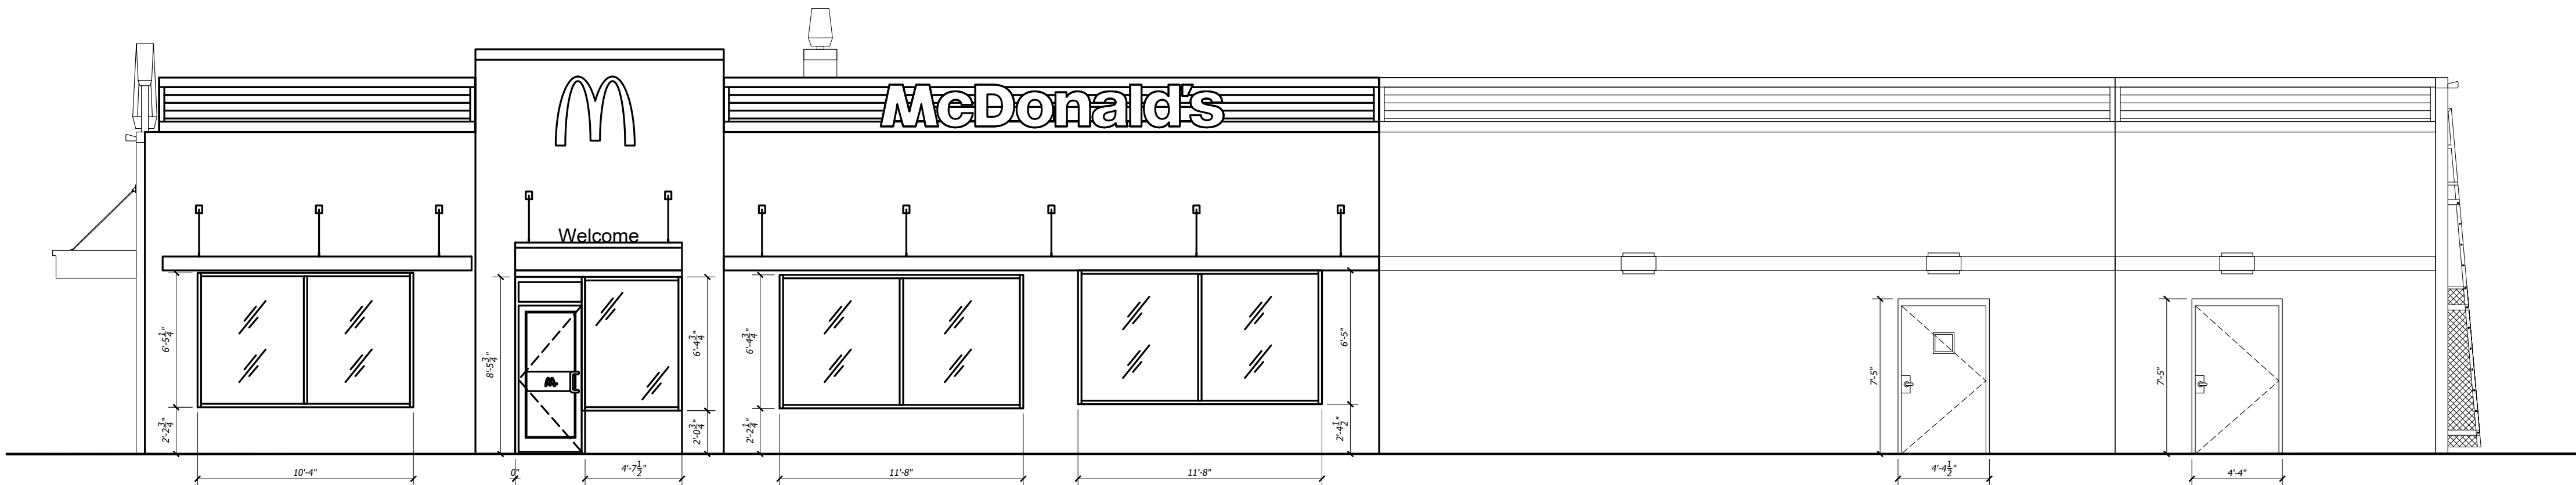

SIDE ELEVATION
SCALE : 3/16" = 1'

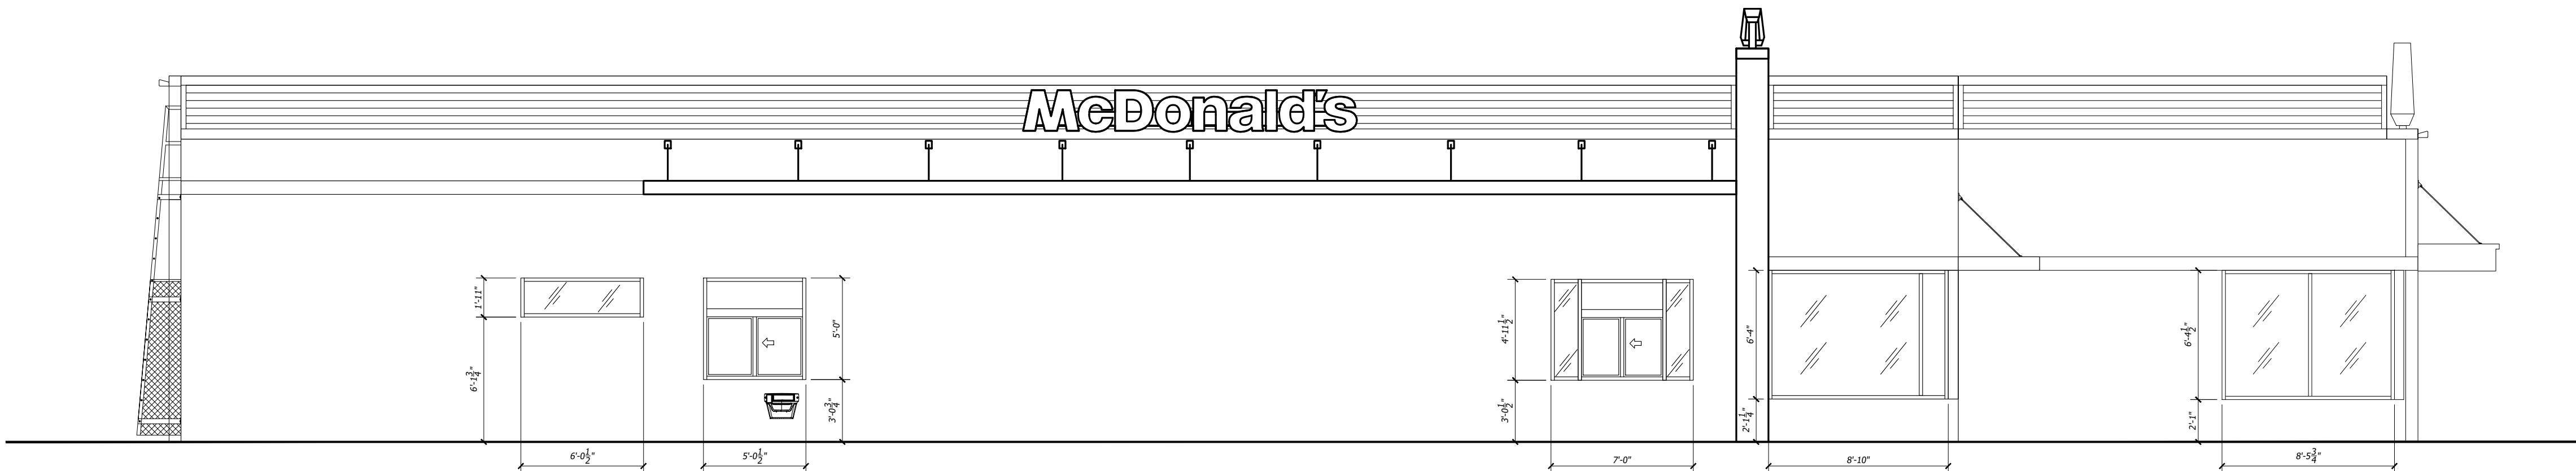

SIDE ELEVATION
SCALE : 3/16" = 1'

H + K INTERNATIONAL

H + K DALLAS INC.
2200 SKYLINE DR.
MESQUITE, TX 75149
214.818.3500

DATE : 25APR22

DRAWN : EC

CHECKED: OP

SCALE : SEE PLAN

[illegible]

T I T L E :

MRP 360

EQUIPMENT TAGS LAYOUT

**2811 N KANSAS EXPWY
SPRINGFIELD, MO**

THESE DRAWINGS SPECIFICATIONS ARE THE PROPERTY OF H+K AND SHALL NOT BE REPRODUCED OR COPIED WITHOUT H+K'S WRITTEN PERMISSION

**McDONALD'S
CORPORATION**
OAK BROOK, ILLINOIS

STORE # :

13526


240453

S H E E T #

7 OF 11

S H E E T :

AB-7

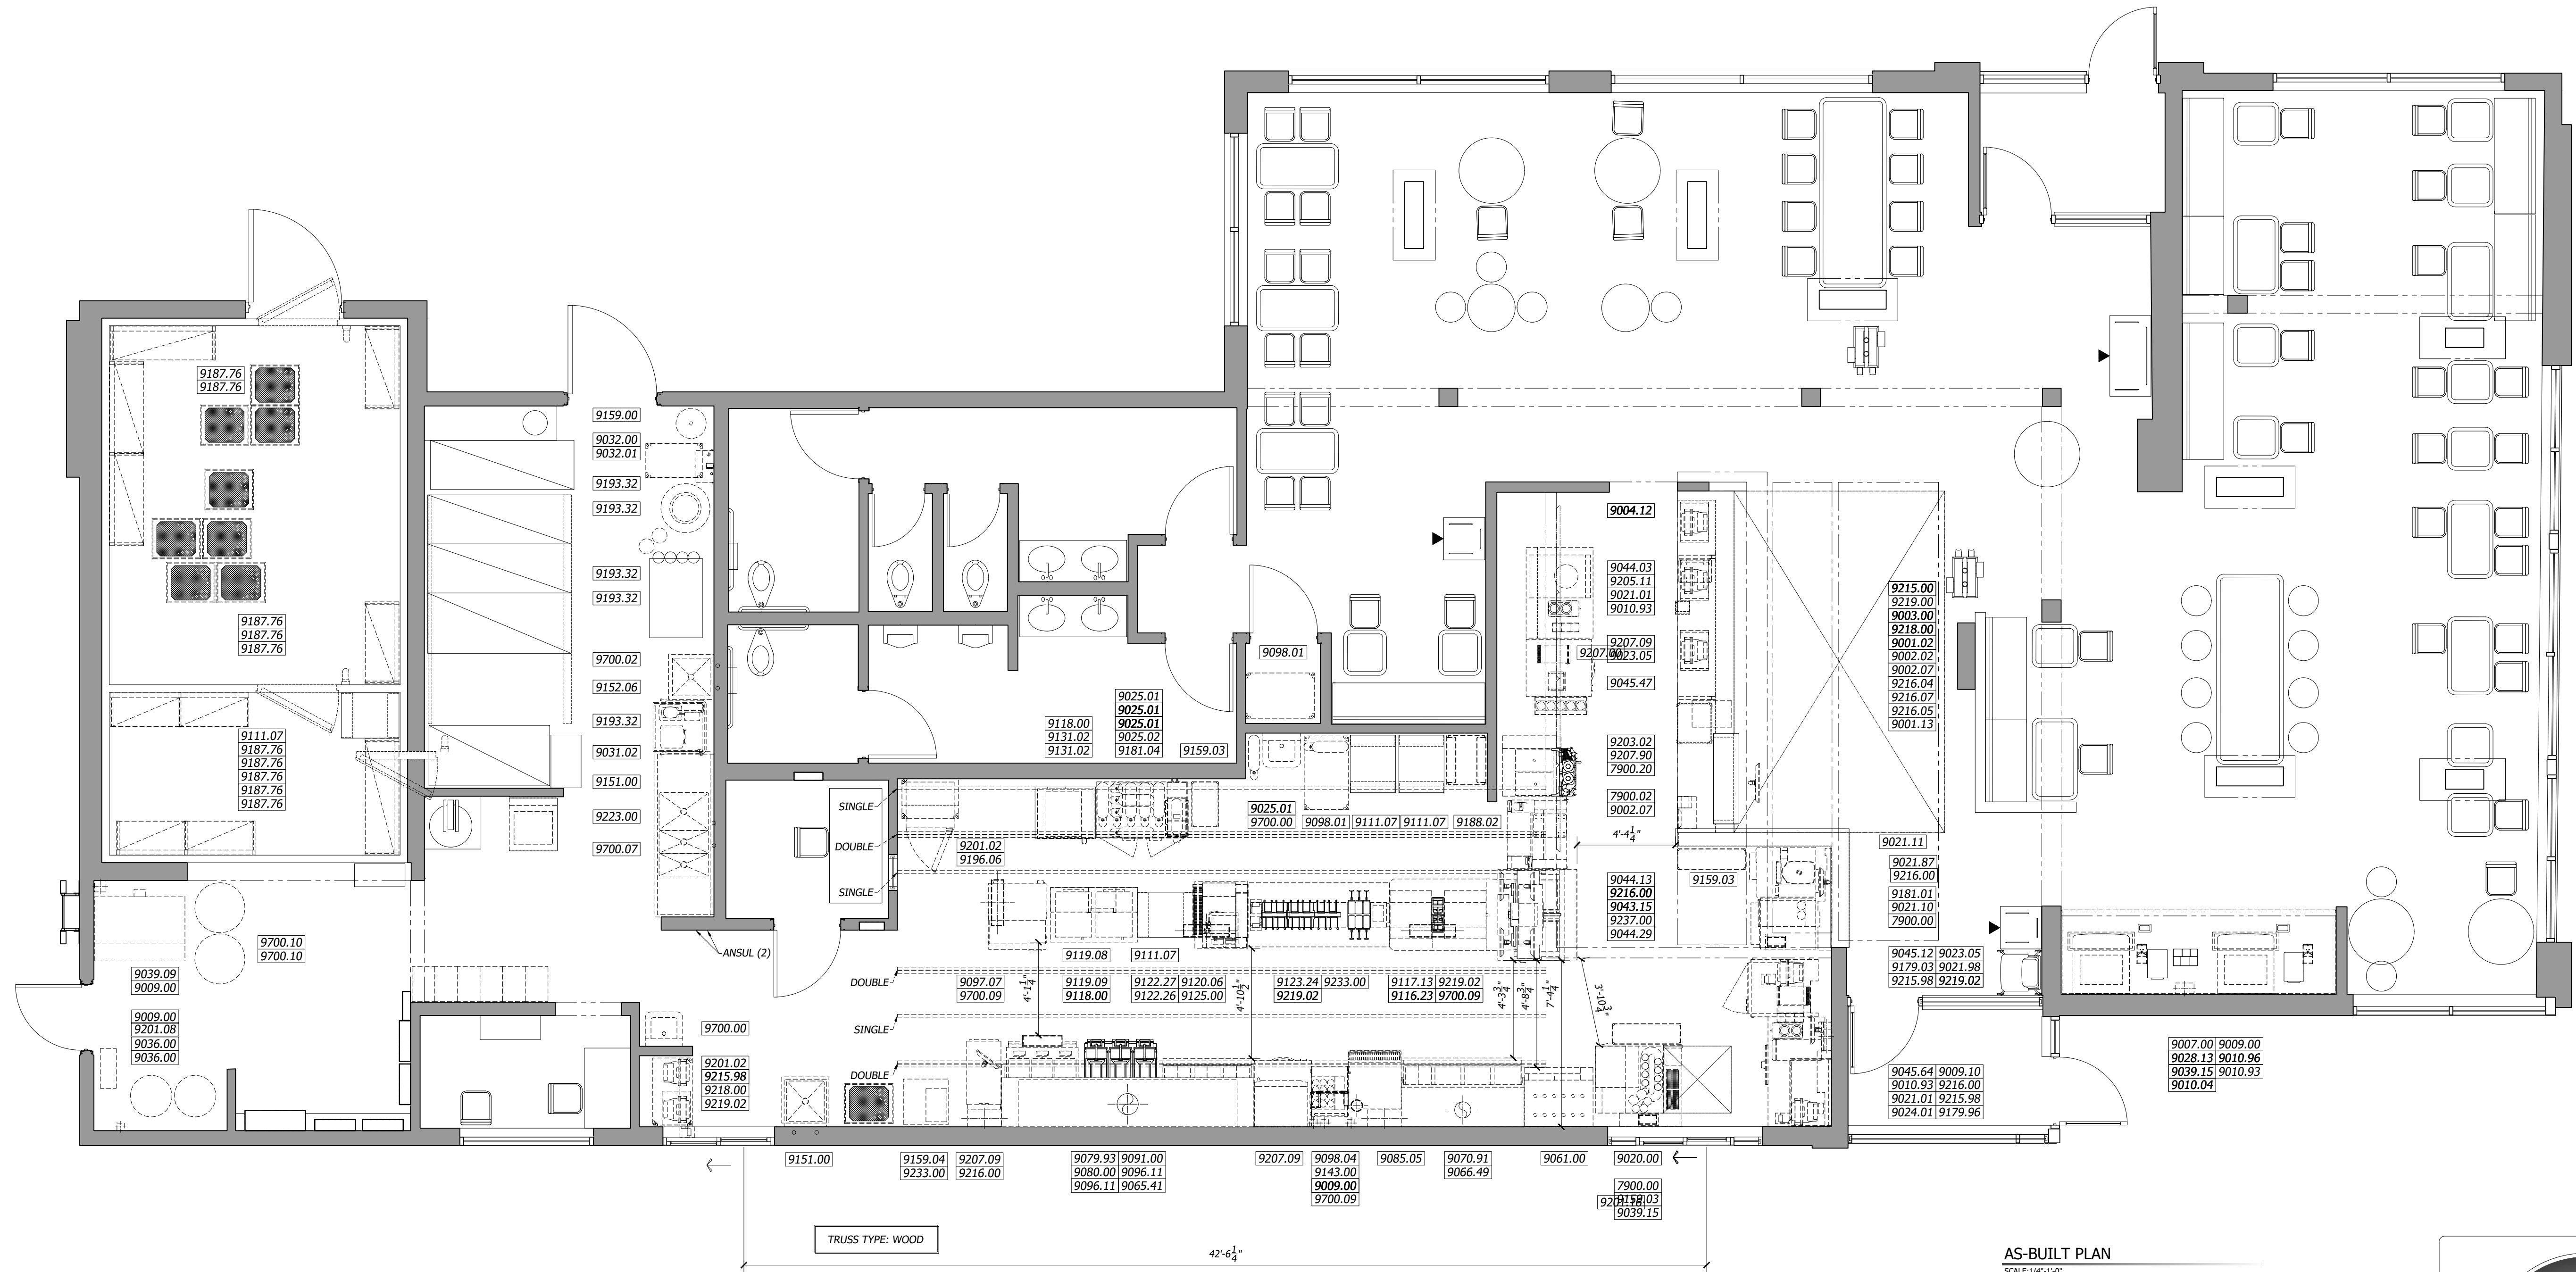

AS-BUILT PLAN
SCALE: 1/4"=1'-0"



3D VIRTUAL TOUR LINK
(PDF DRAWING VERSION ONLY)
CLICK TO VIEW THE 360 VIRTUAL WALKTHROUGH



3D VIRTUAL TOUR LINK
SCAN QR CODE TO VIEW 360 VIRTUAL WALKTHROUGH

LEGEND

- EXISTING EQUIPMENT
----- EXISTING TRUSSES
_____ SERVICE AREA
----- OVERHEAD
[Shaded Box] EXISTING FULL WALL
_____ EXISTING LOW WALL

DATE : 25APR22

DRAWN : EC

CHECKED: ☐ OFF

SCALE : SEE PLAN

[illegible]

MRP 360

ELECTRICAL LAYOUT

**2811 N KANSAS EXPWY
SPRINGFIELD, MO**

THESE DRAWINGS SPECIFICATIONS ARE THE PROPERTY
OF H+K AND SHALL NOT BE REPRODUCED OR COPIED
WITHOUT H+K'S WRITTEN PERMISSION

McDONALD'S CORPORATION

OAK BROOK, ILLINOIS

STORE # :

13526


240453

S H E E T #

8 OF 11

S H E E T :

AB-8

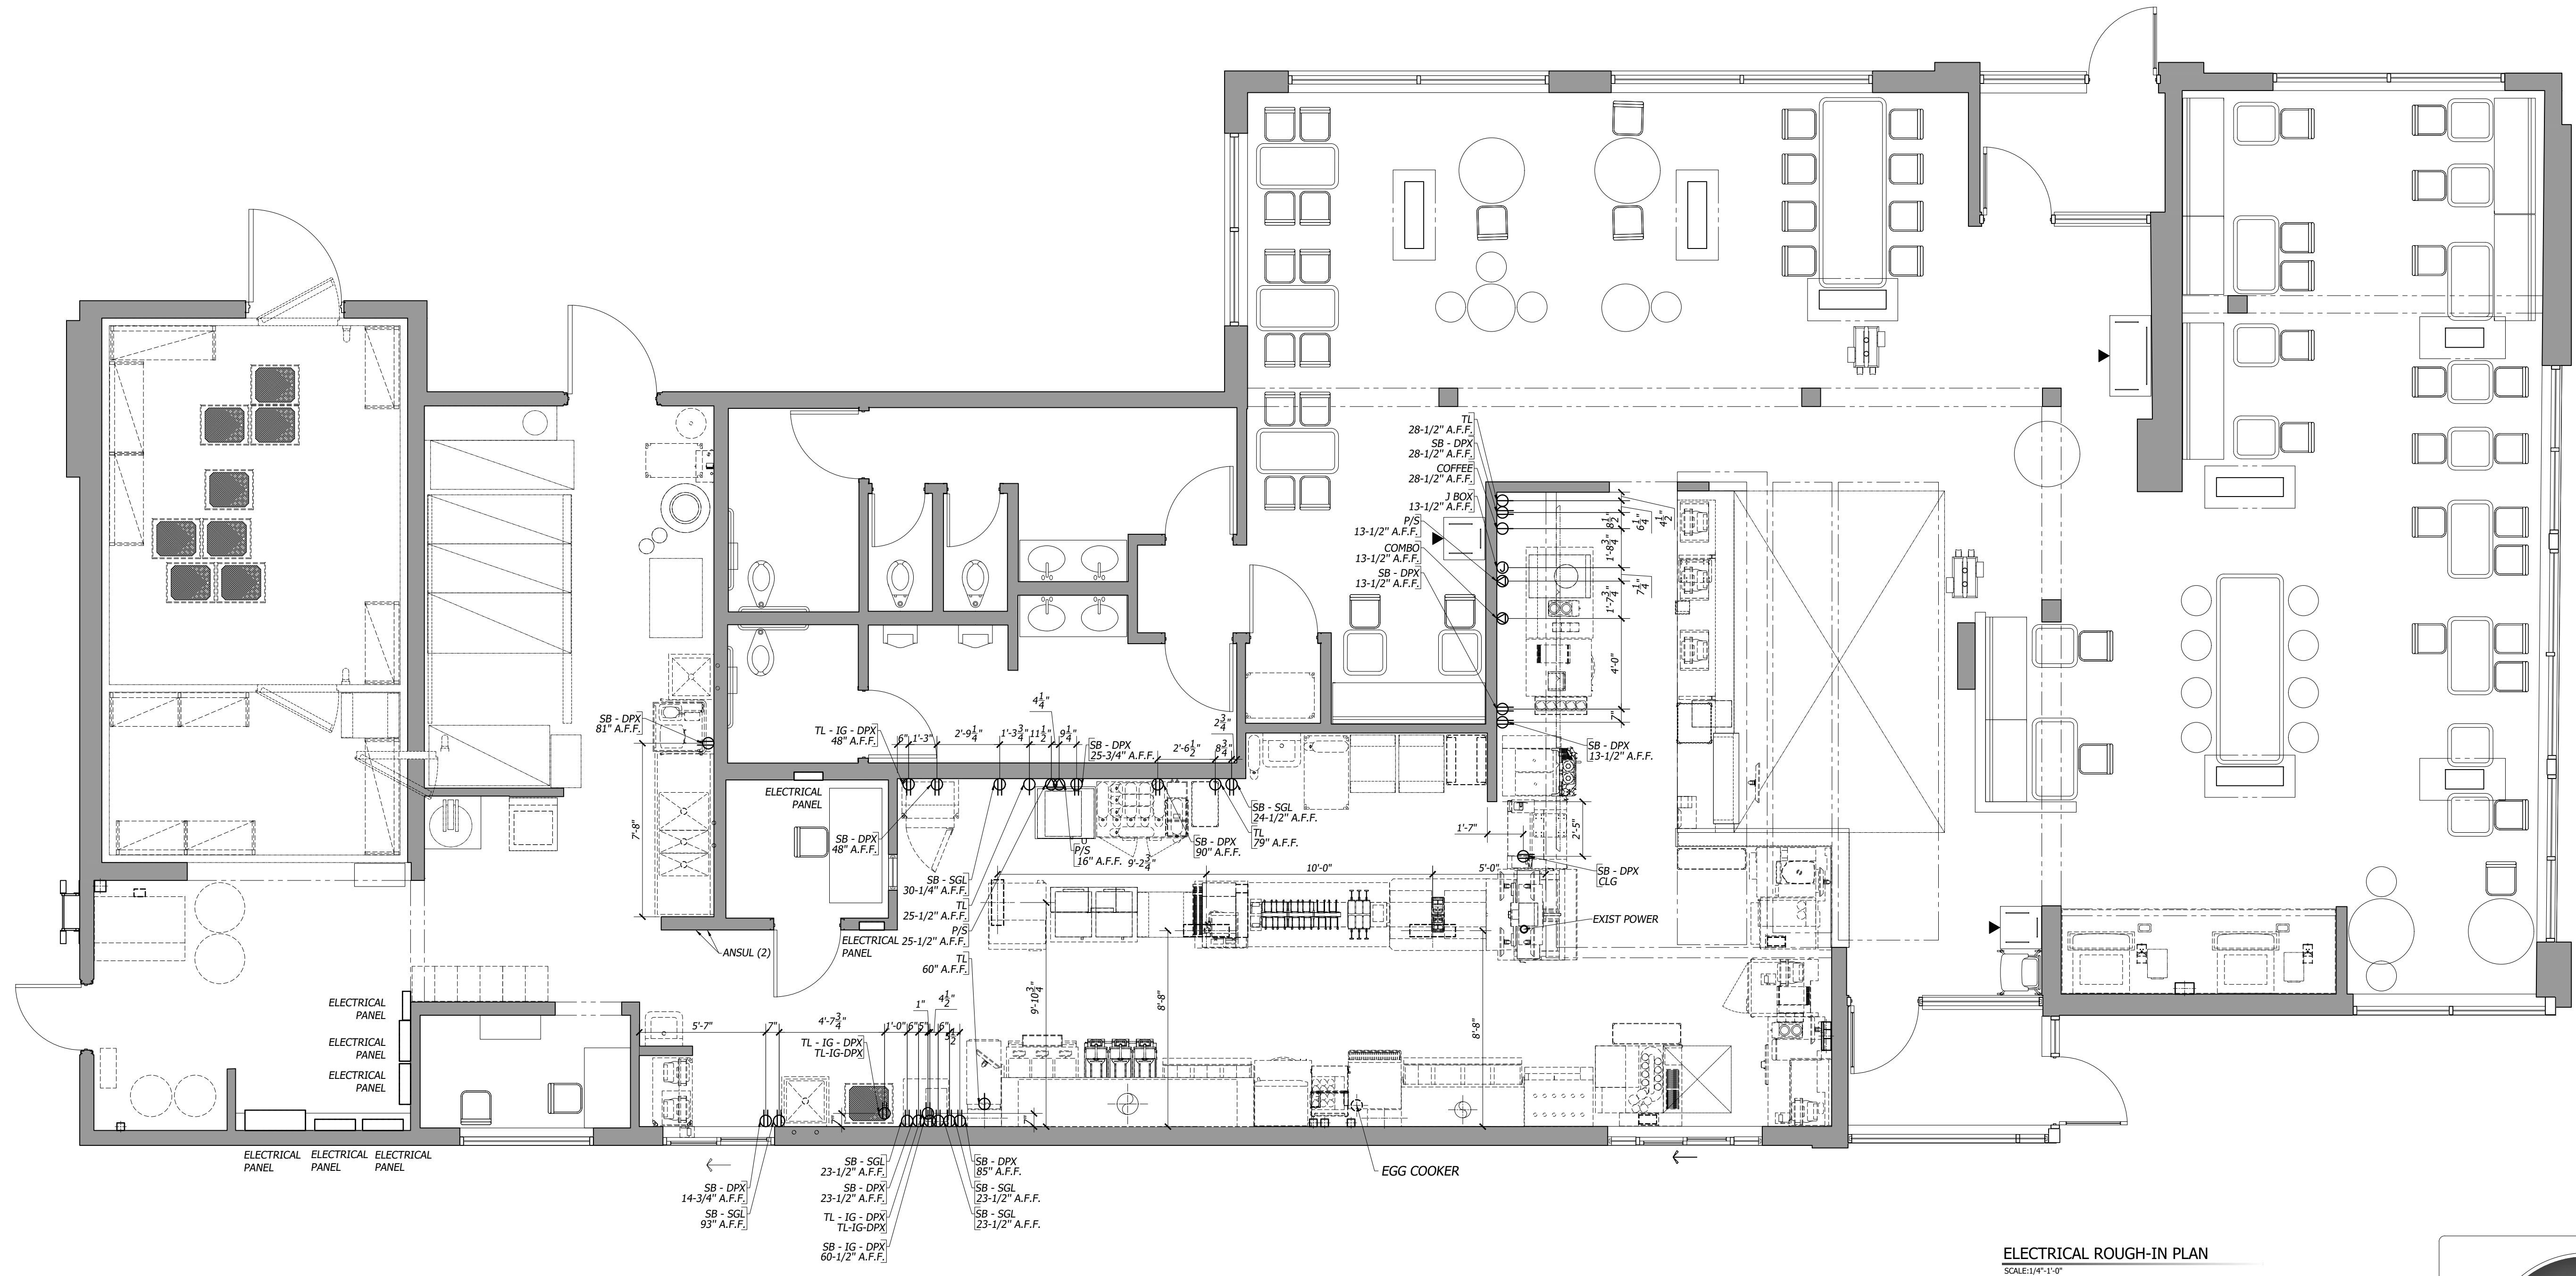

ELECTRICAL ROUGH-IN PLAN
SCALE: 1/4"=1'-0"





3D VIRTUAL TOUR LINK
(PDF DRAWING VERSION ONLY)
CLICK TO VIEW THE 360 VIRTUAL WALKTHROUGH



3D VIRTUAL TOUR LINK
SCAN QR CODE TO VIEW 360 VIRTUAL WALKTHROUGH


LEGEND

- EXISTING EQUIPMENT
 ----- EXISTING TRUSSES
 _____ SERVICE AREA
 ----- OVERHEAD
 [Shaded Box] EXISTING FULL WALL
 _____ EXISTING LOW WALL

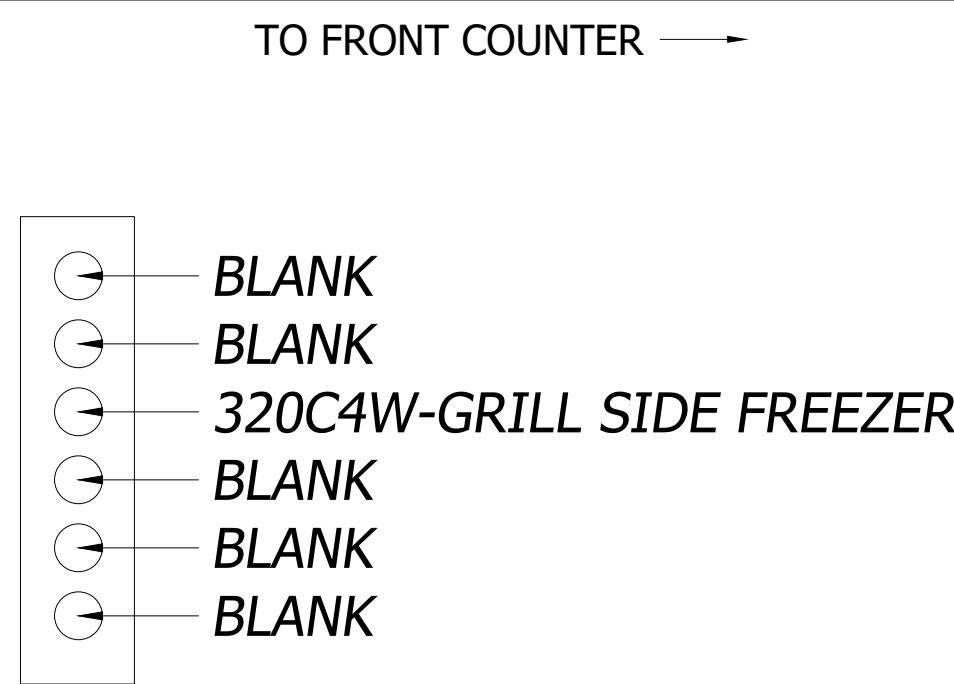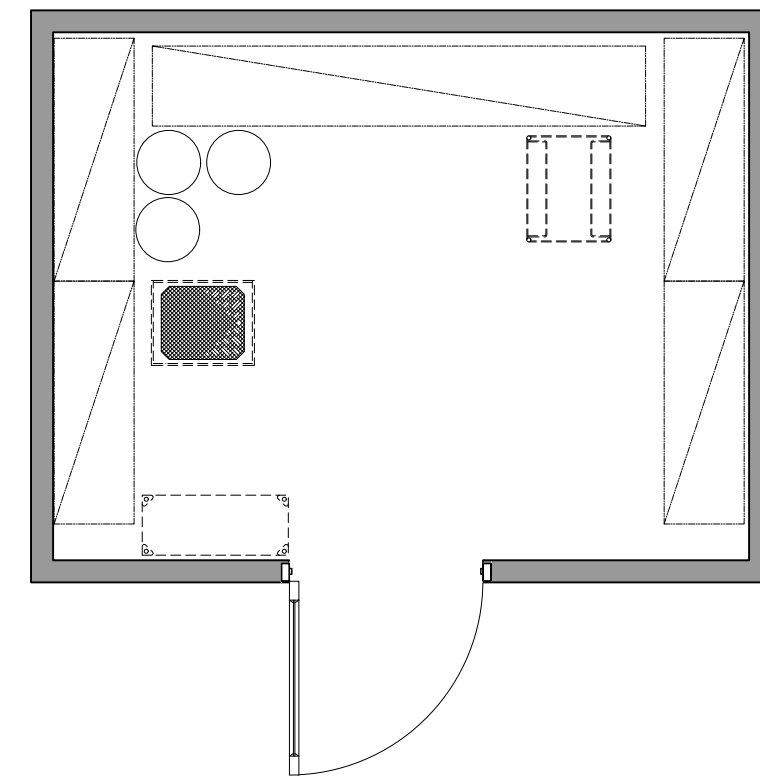


DETAIL OEP "C"

N.T.S.

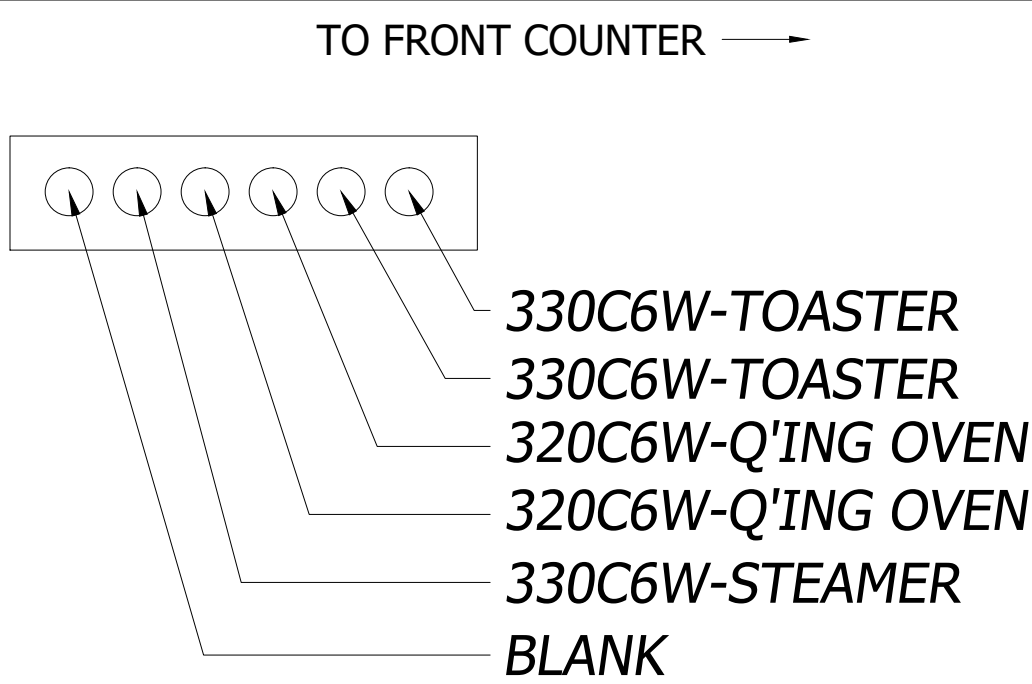

DETAIL OEP "B"

N.T.S.

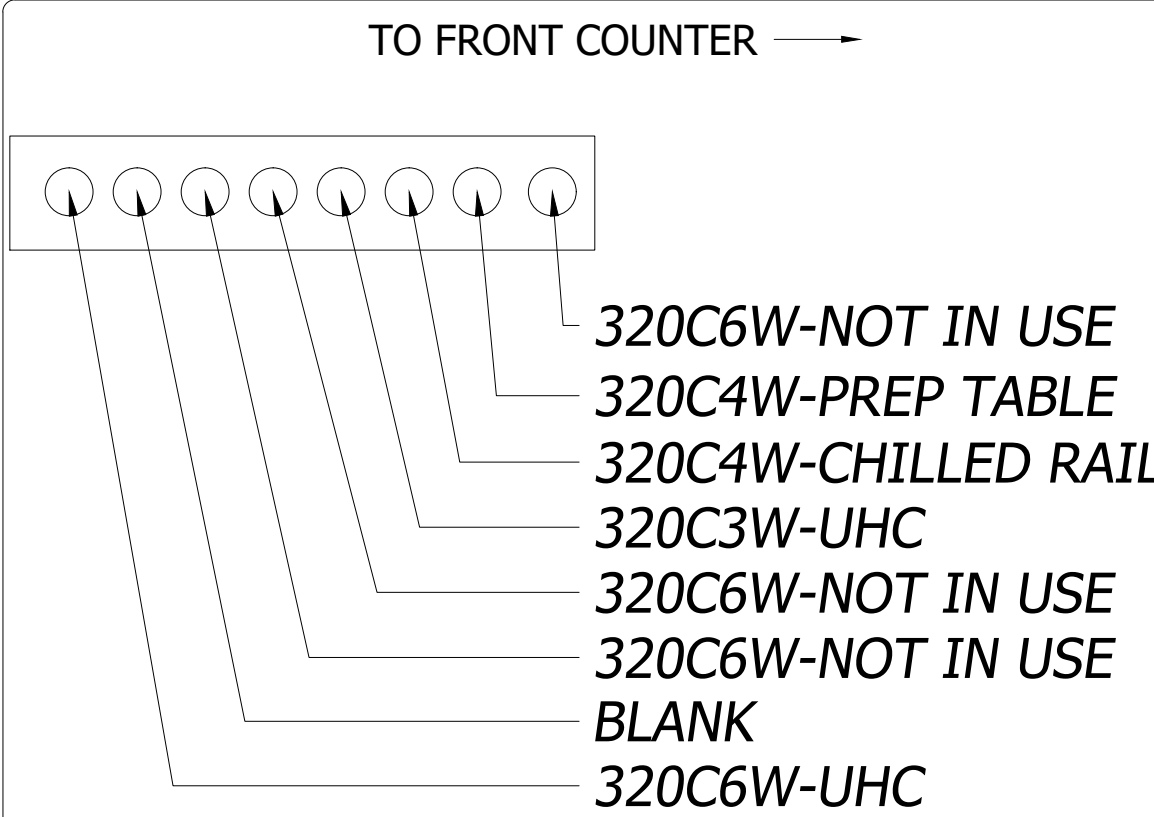

DETAIL OEP "A"

N.T.S.

H + K INTERNATIONAL

H + K DALLAS INC.
2200 SKYLINE DR.
MESQUITE, TX 75149
214.818.3500

DATE : 25APR22

DRAWN : EC

CHECKED: OF

SCALE : SEE PLAN

[illegible]

MRP 360

PLUMBING LAYOUT

**2811 N KANSAS EXPWY
SPRINGFIELD, MO**

THESE DRAWINGS SPECIFICATIONS ARE THE PROPERTY
OF H+K AND SHALL NOT BE REPRODUCED OR COPIED
WITHOUT H+K'S WRITTEN PERMISSION

McDONALD'S
CORPORATION
OAK BROOK, ILLINOIS

STORE # :

13526


240453

SHEET #

9 OF 11

S H E E T :

AB-9

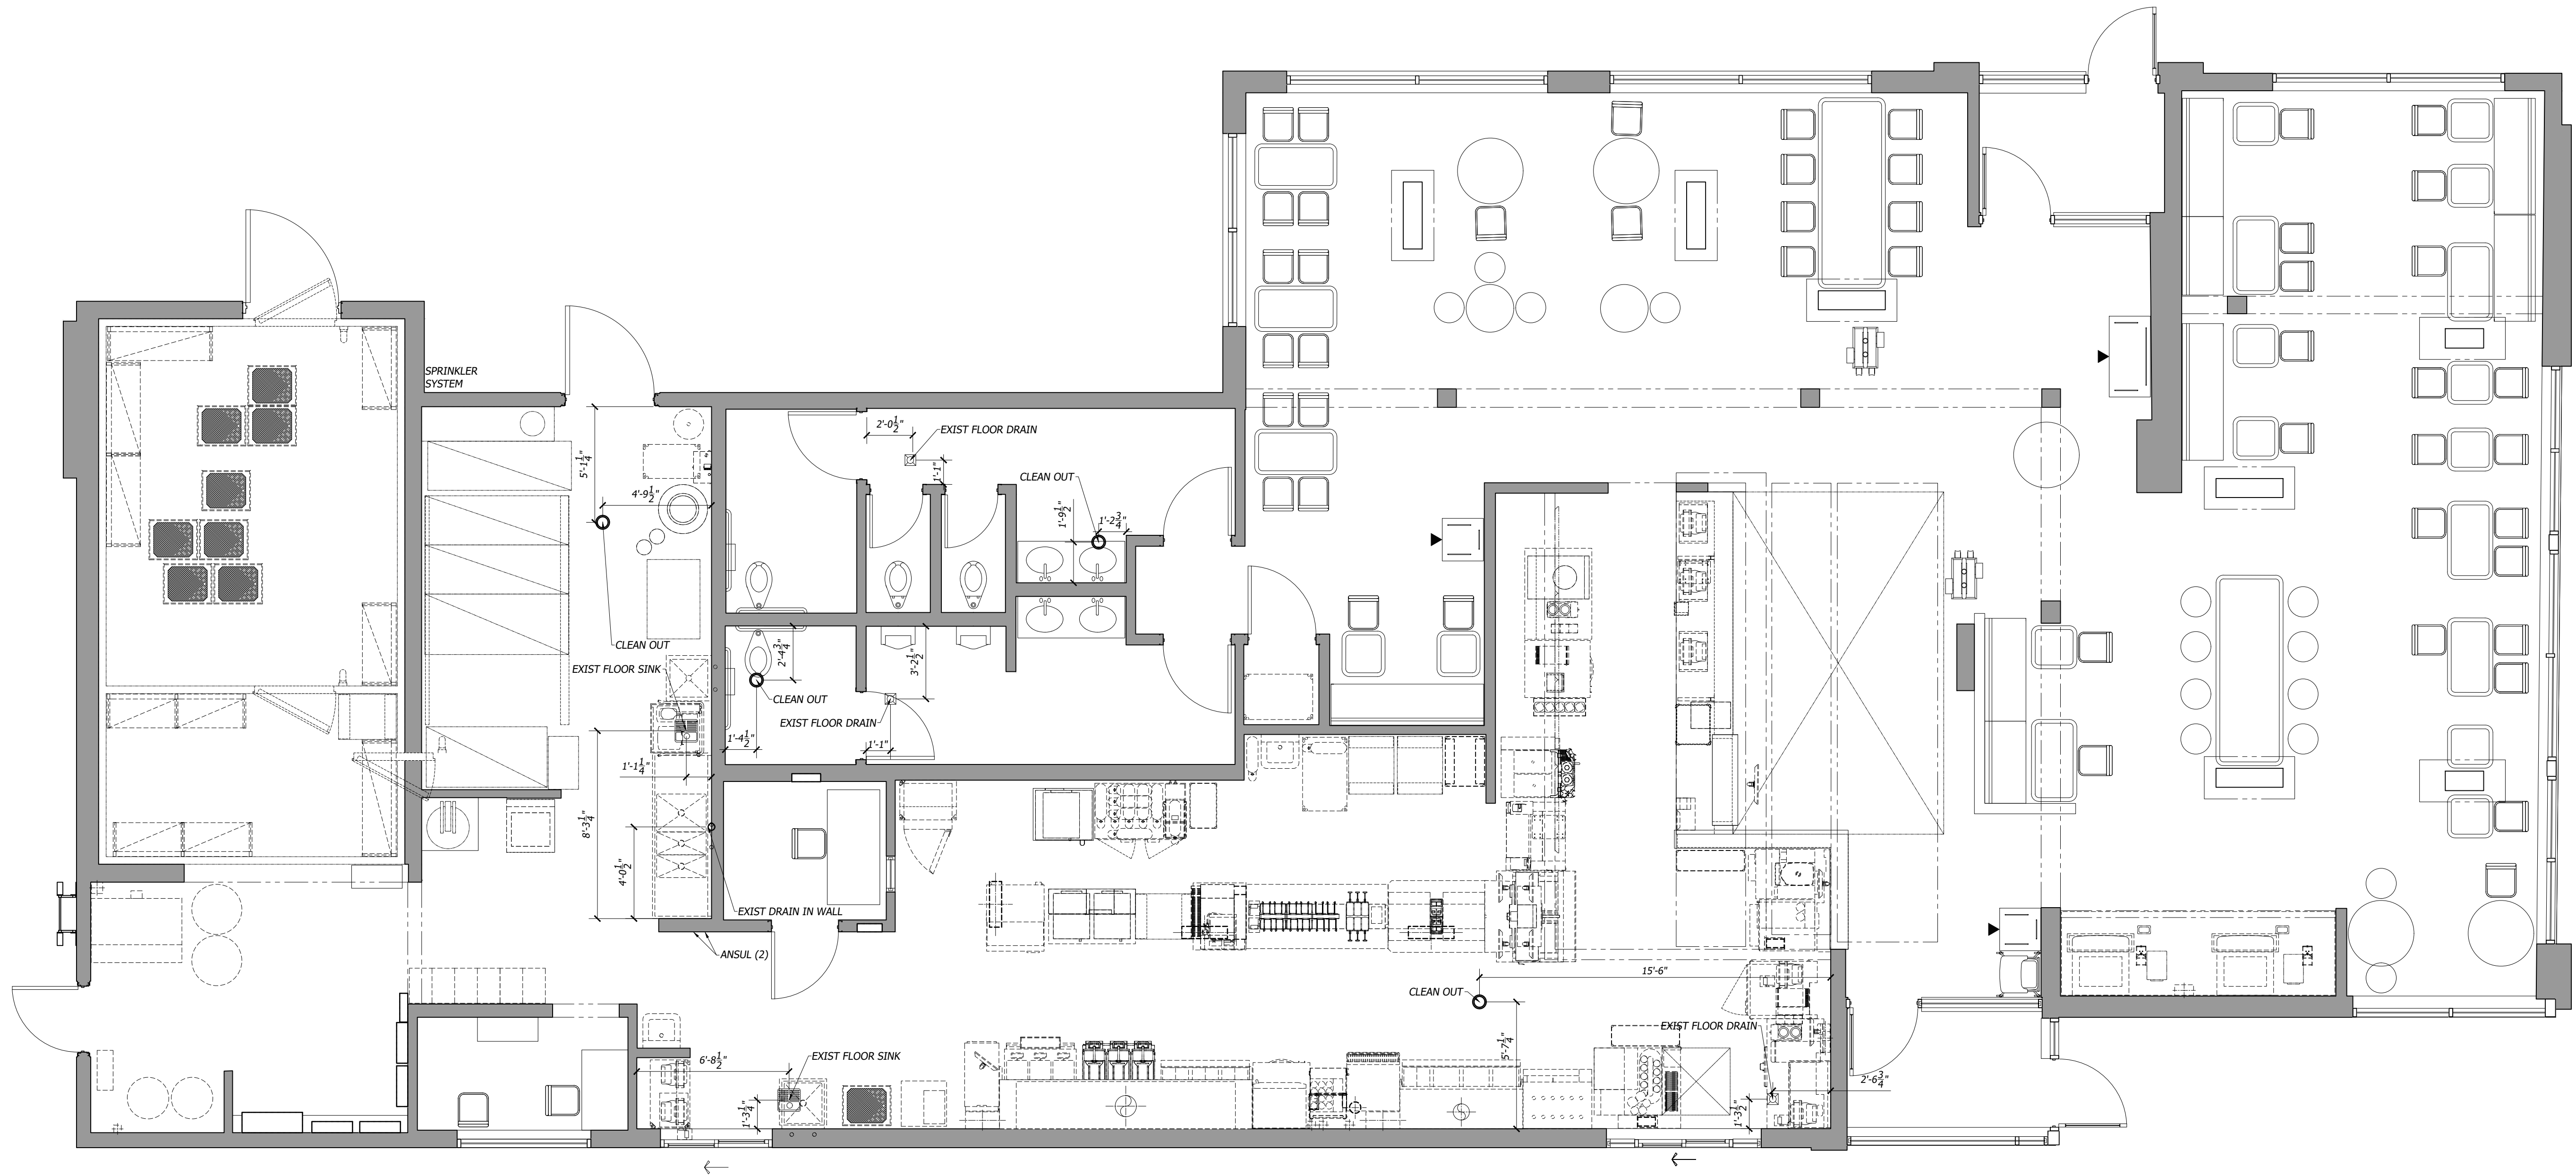

PLUMBING ROUGH-IN PLAN
SCALE: 1/4"=1'-0"




3D VIRTUAL TOUR LINK
(PDF DRAWING VERSION ONLY)
CLICK TO VIEW THE 360 VIRTUAL WALKTHROUGH



3D VIRTUAL TOUR LINK
SCAN QR CODE TO VIEW 360 VIRTUAL WALKTHROUGH

LEGEND

- EXISTING EQUIPMENT
 ----- EXISTING TRUSSES
 _____ SERVICE AREA
 ----- OVERHEAD
 [Shaded Box] EXISTING FULL WALL
 _____ EXISTING LOW WALL

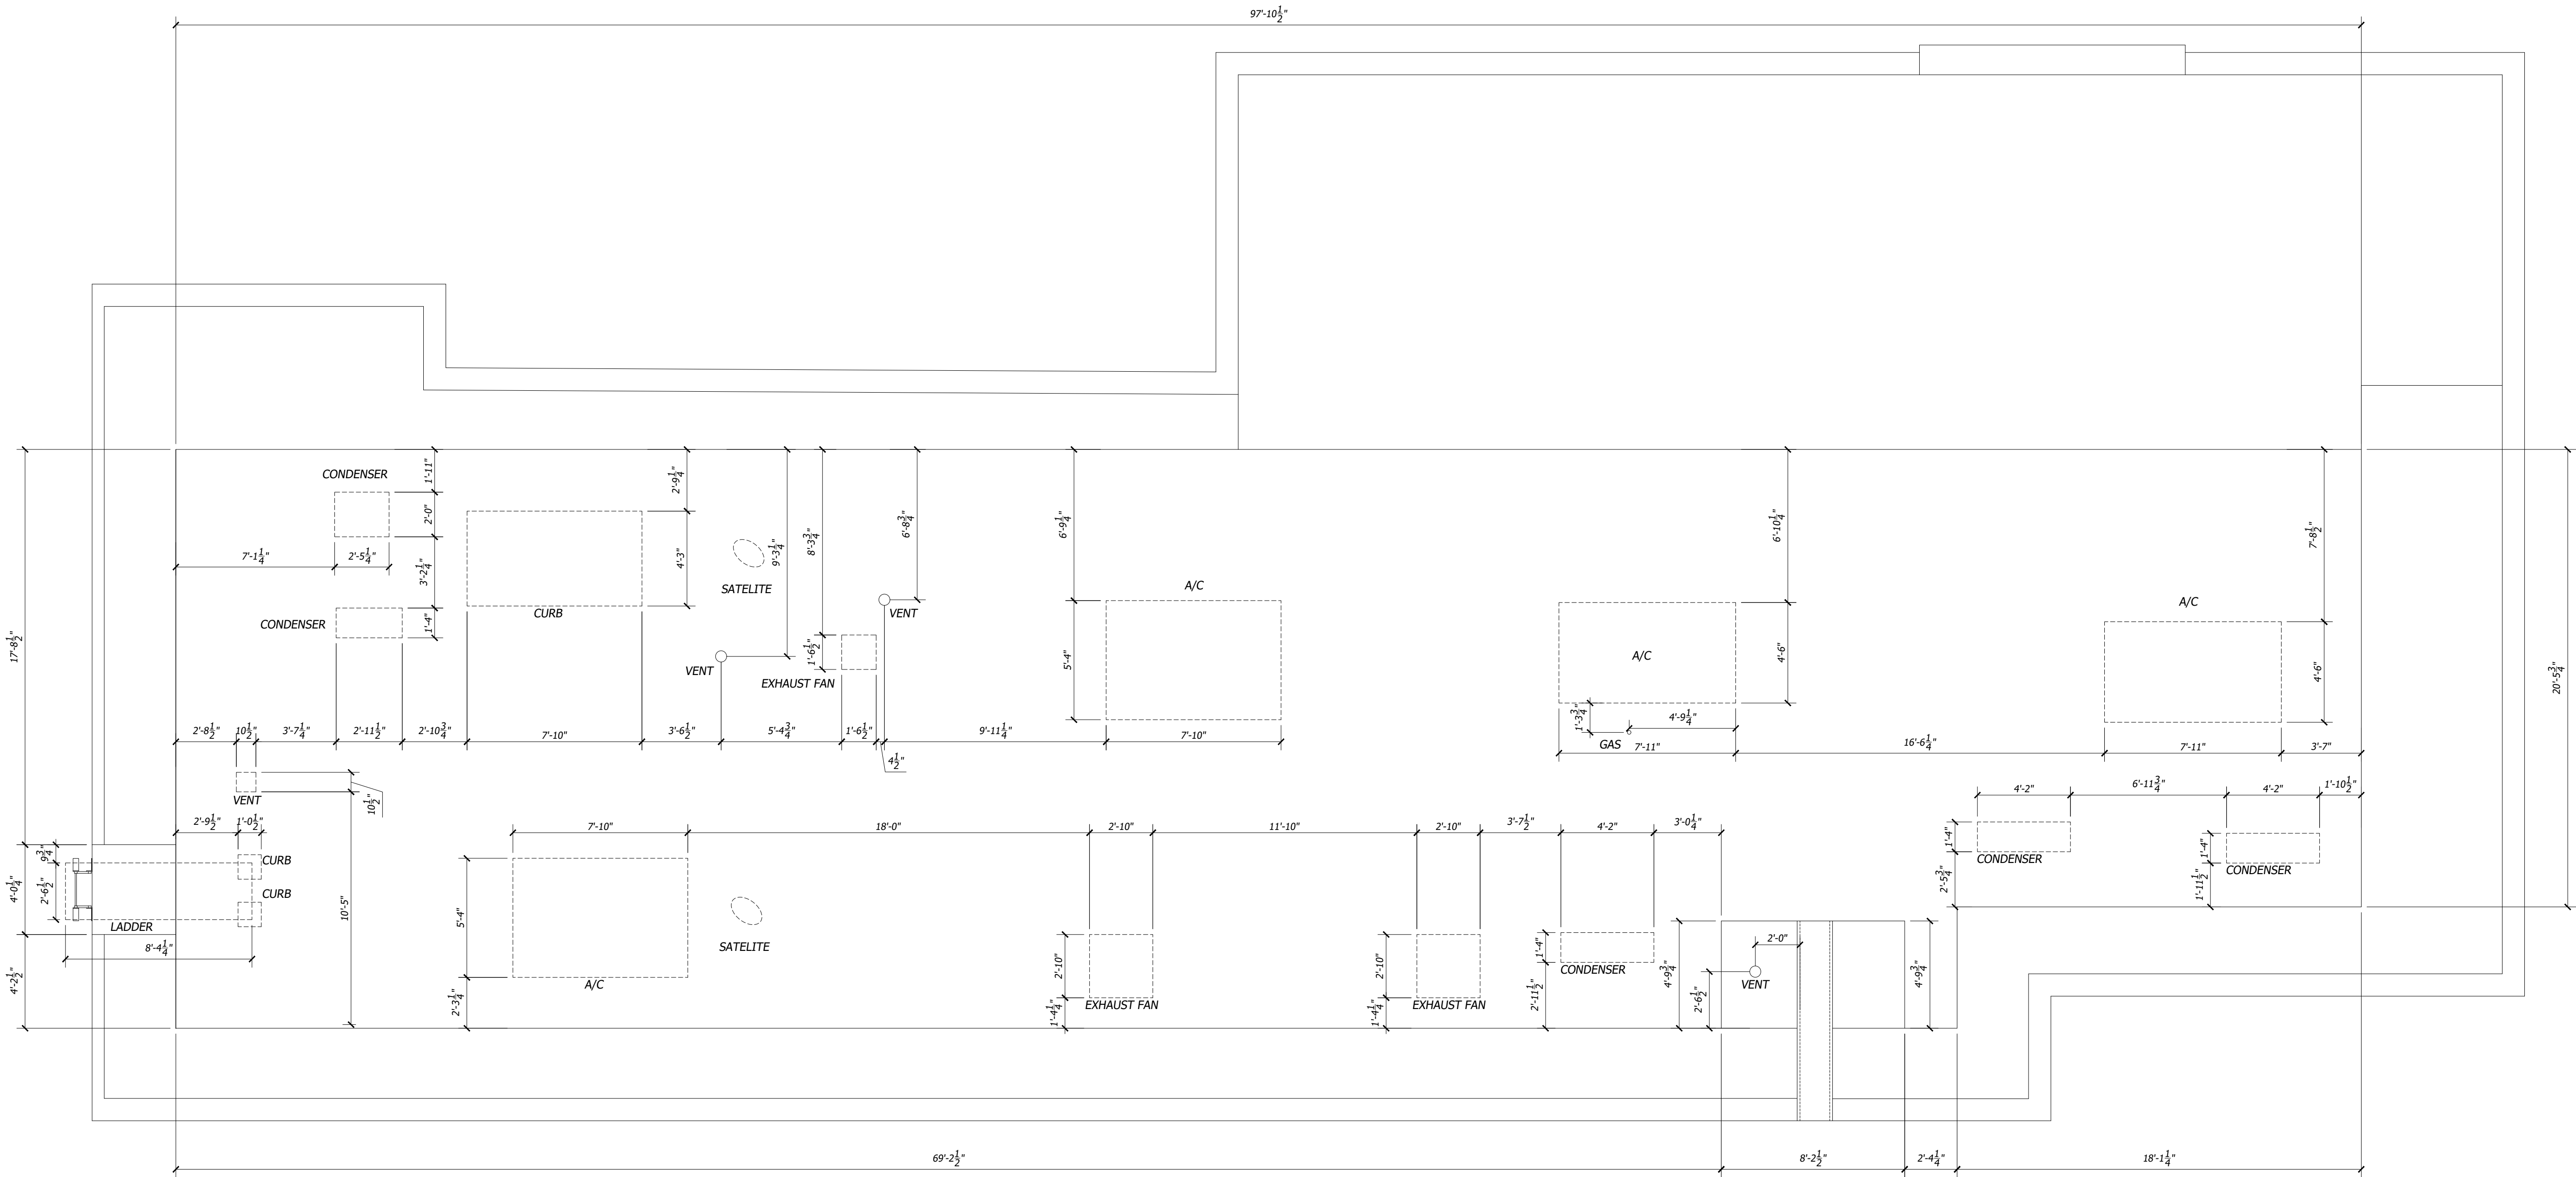

AS-BUILT ROOF PLAN
SCALE: 1/4"=1'-0"



3D VIRTUAL TOUR LINK
(PDF DRAWING VERSION ONLY)
CLICK TO VIEW THE 360 VIRTUAL WALKTHROUGH



3D VIRTUAL TOUR LINK
SCAN QR CODE TO VIEW 360 VIRTUAL WALKTHROUGH

LEGEND

- EXISTING EQUIPMENT
- EXISTING TRUSSES
- SERVICE AREA
- OVERHEAD
- ===== EXISTING FULL WALL
- ===== EXISTING LOW WALL



H + K INTERNATIONAL

H + K DALLAS INC.
2200 SKYLINE DR.
MESQUITE, TX 75149
214.818.3500

DATE : 25APR22

DRAWN : EC

CHECKED : OP

SCALE : SEE PLAN

BY					
DESCRIPTION					
REV					
DATE					

TITLE :

MRP 360
ROOF LAYOUT

2811 N KANSAS EXPWY
SPRINGFIELD, MO

THESE DRAWINGS SPECIFICATIONS ARE THE PROPERTY
OF H+K AND SHALL NOT BE REPRODUCED OR COPIED
WITHOUT H+K'S WRITTEN PERMISSION

CUSTOMER :

McDONALD'S
CORPORATION
OAK BROOK, ILLINOIS

STORE # :

13526

SITE ID :

240453

SHEET #

10 OF 11

SHEET :

AB-10



H + K INTERNATIONAL

H + K DALLAS INC.
2200 SKYLINE DR.
MESQUITE, TX 75149
2 1 4 . 8 1 8 . 3 5 0 0

DATE : 25APR22

DRAWN : EC

CHECKED : OP

SCALE : SEE PLAN

BY						
DESCRIPTION						
REV						
DATE						

TITLE :

MRP 360
SCHEDULES

2811 N KANSAS EXPWY
SPRINGFIELD, MO

THESE DRAWINGS SPECIFICATIONS ARE THE PROPERTY
OF H+K AND SHALL NOT BE REPRODUCED OR COPIED
WITHOUT H+K'S WRITTEN PERMISSION

CUSTOMER :

MCDONALD'S
CORPORATION
OAK BROOK, ILLINOIS

STORE # :

13526

SITE ID :

240453

SHEET #

11 OF 11

SHEET :

AB-11

EQUIPMENT SCHEDULE									
ITEM #	QTY	OPT	ITEM DESCRIPTION	MFR	UNIT ID	UL LIST	NSF LIST	FURN BY	REMARKS
7900.00	2	E	EXISTING OATMEAL	-	-	-	-	OWNER	-
7900.02	1	E	EXISTING DUAL POINT ORDER ASSEMBLY TABLE/OVERSHELF	-	-	-	-	OWNER	-
7900.20	1	E	DESSERT BUTLER	-	-	-	-	OWNER	-
9001.02	2	E	EXISTING FRONT COUNTER SUPPORT	-	-	-	-	OWNER	-
9001.13	1	E	MODULAR FRONT COUNTER OVERSHELF	-	-	-	-	OWNER	-
9002.02	1	E	EXISTING UNDER COUNTER CART	-	-	-	-	OWNER	-
9002.07	2	E	EXISTING TRAY CART	-	-	-	-	OWNER	-
9003.00	3	E	EXISTING CASH DRAWER SHELF	-	-	-	-	OWNER	-
9004.12	4	E	EXISTING DIGITAL MENU BOARD	-	-	-	-	OWNER	-
9007.00	1	E	EXISTING SELF-SERVE BEVERAGE STATION	-	-	-	-	OWNER	-
9009.00	6	E	EXISTING UTILITY CHASE	-	-	-	-	OWNER	-
9009.10	1	E	EXISTING UTILITY CHASE F/ DRIVE THRU CBB	-	-	-	-	OWNER	-
9010.04	2	E	EXISTING CO2 DRIVEN KETCHUP DISPENSER	-	-	-	-	OWNER	-
9010.93	3	E	EXISTING CUP LID HOLDER	-	-	-	-	OWNER	-
9010.96	2	E	EXISTING NAPKIN DISPENSER	-	-	-	-	OWNER	-
9020.00	1	E	EXISTING AUTOMATED BEVERAGE SYSTEM	-	-	-	-	OWNER	-
9021.01	2	E	EXISTING COFFEE BREWER	-	-	-	-	OWNER	-
9021.10	1	E	EXISTING SPECIALTY COFFEE	-	-	-	-	OWNER	-
9021.11	1	E	EXISTING BLENDED ICE MACHINE	-	-	-	-	OWNER	-
9021.87	1	E	EXISTING STANDOFF, COFFEE/SMOOTHIE STATIONS	-	-	-	-	OWNER	-
9021.98	1	E	EXISTING SUGAR DISPENSER	-	-	-	-	OWNER	-
9023.05	2	E	EXISTING COFFEE CREAM DISPENSER	-	-	-	-	OWNER	-
9024.01	1	E	EXISTING ORANGE JUICE DISPENSER	-	-	-	-	OWNER	-
9025.01	12	E	EXISTING ICED BEVERAGE DISPENSER	-	-	-	-	OWNER	-
9025.02	1	E	EXISTING ICED TEA BREWER	-	-	-	-	OWNER	-
9028.13	2	E	EXISTING SODA TOWER	-	-	-	-	OWNER	-
9031.02	1	E	EXISTING SODA SYSTEM PACKAGE B.I.B.(RECIRCULATING)	-	-	-	-	OWNER	-
9032.00	1	E	EXISTING REVERSE OSMOSIS WATER FILTRATION SYSTEM	-	-	-	-	OWNER	-
9032.01	1	E	EXISTING REVERSE OSMOSIS WATER FILTRATION SYSTEM - TANK	-	-	-	-	OWNER	-
9036.00	2	E	EXISTING BULK COKE	-	-	-	-	OWNER	-
9039.09	1	E	EXISTING ICE MACHINE	-	-	-	-	OWNER	-
9039.15	3	E	EXISTING ICE MACHINE - 1000 LB.	-	-	-	-	OWNER	-
9043.15	2	E	EXISTING HEATED LANDING ZONE	-	-	-	-	OWNER	-
9044.03	1	E	EXISTING 5' CENTER ISLAND, BEV HEIGHT	-	-	-	-	OWNER	-
9044.13	1	E	EXISTING CENTER ISLAND- 48" HLZ HEIGHT	-	-	-	-	OWNER	-
9044.29	1	E	EXISTING BREAKER PANEL - EQUIPMENT MOUNTED	-	-	-	-	OWNER	-
9045.12	1	E	EXISTING BEVERAGE CABINET - DRIVE-THRU - 30 1/2" WIDE (CBB)	-	-	-	-	OWNER	-
9045.47	1	E	EXISTING MOBILE CUP CART	-	-	-	-	OWNER	-
9045.64	1	E	EXISTING BEVERAGE CABINET - DRIVE-THRU	-	-	-	-	OWNER	-
9061.00	1	E	EXISTING FRY BAGGING STATION	-	-	-	-	OWNER	-
9065.41	1	E	EXISTING 3-VAT FRYER - GAS - S/S/S	-	-	-	-	OWNER	-
9066.49	1	E	EXISTING 4-VAT FRYER - GAS - F/F/F/S	-	-	-	-	OWNER	-
9070.91	1	E	EXISTING EXHAUST HOOD	-	-	-	-	OWNER	-
9079.93	1	E	EXISTING UNIVERSAL EXHAUST HOOD (R.H.) (ELEC 2 FULL-CLAMS)(GAS 3-VAT FRYER)	-	-	-	-	OWNER	-
9080.00	1	E	EXISTING MECHANICAL CHASE, 9"x18" SGCL	-	-	-	-	OWNER	-
9085.05	1	E	EXISTING FROZEN FRY DISPENSER	-	-	-	-	OWNER	-
9091.00	1	E	EXISTING WALL MOUNT FREEZER-SINGLE WIDE	-	-	-	-	OWNER	-
9096.11	2	E	EXISTING 36" CLAMSHELL GRILL - 3 PLATEN - ELECTRIC	-	-	-	-	OWNER	-
9097.07	1	E	EXISTING GRILL SIDE MEAT FREEZER - DOUBLE WIDE	-	-	-	-	OWNER	-
9098.01	3	E	EXISTING 3-TIER APPLIANCE STAND	-	-	-	-	OWNER	-
9098.04	1	E	EXISTING EGG COOKER TABLE	-	-	-	-	OWNER	-
9111.07	4	E	EXISTING BUN CART	-	-	-	-	OWNER	-
9116.23	2	E	EXISTING UNIVERSAL HOLDING CABINET - HD - 2-SIDED - P&S	-	-	-	-	OWNER	-
9117.13	1	E	EXISTING UHC TABLE - 2 SIDED	-	-	-	-	OWNER	-
9118.00	3	E	EXISTING QTING OVEN	-	-	-	-	OWNER	-
9119.08	1	E	EXISTING QTING OVEN BREAKFAST TABLE	-	-	-	-	OWNER	-
9119.09	1	E	EXISTING QTING OVEN BREAKFAST TABLE RETROFIT SHELF	-	-	-	-	OWNER	-
9120.06	1	E	EXISTING TOASTER TABLE	-	-	-	-	OWNER	-
9122.26	1	E	EXISTING HCT TOASTER - P&S	-	-	-	-	OWNER	-
9122.27	1	E	EXISTING HRT TOASTER - P&S	-	-	-	-	OWNER	-
9123.24	1	E	EXISTING PREP TABLE	-	-	-	-	OWNER	-
9125.00	1	E	EXISTING RAPID FILET BUN STEAMER	-	-	-	-	OWNER	-
9131.02	2	E	EXISTING BISCUIT OVEN	-	-	-	-	OWNER	-
9143.00	1	E	EXISTING EGG COOKER	-	-	-	-	OWNER	-
9151.00	2	E	EXISTING WORK SINK - 3 COMPARTMENT	-	-	-	-	OWNER	-
9152.06	1	E	EXISTING WAREWASHER PASS THRU/CORNER UNIT	-	-	-	-	OWNER	-
9159.00	1	E	EXISTING UNIVERSAL PARTS CART	-	-	-	-	OWNER	-
9159.03	3	E	EXISTING CART	-	-	-	-	OWNER	-
9159.04	1	E	EXISTING SS TABLE	-	-	-	-	OWNER	-
9179.03	1	E	EXISTING REFRIGERATOR - UNDERCOUNTER	-	-	-	-	OWNER	-
9179.96	1	E	EXISTING REFRIGERATOR - 36" WALL HUNG OR STAND MOUNTED	-	-	-	-	OWNER	-
9181.01	1	E	EXISTING SPECIALTY COFFEE REFRIGERATOR-27" WIDE	-	-	-	-	OWNER	-
9181.04	1	E	EXISTING REFRIGERATOR - WORKTOP - 48" WIDE	-	-	-	-	OWNER	-
9187.76	10	E	EXISTING COOLER/FREEZER SHELVING	-	-	-	-	OWNER	-
9188.02	2	E	EXISTING COOLER SHELVING UNIVERSAL HOLDING CART	-	-	-	-	OWNER	-
9193.32	10	E	EXISTING DRY SHELVING - MOBILE	-	-	-	-	OWNER	-
9196.06	1	E	EXISTING SAFE	-	-	-	-	OWNER	-
9201.02	2	E	EXISTING DRIVE-THRU POS STAND W/OVERHEAD SHELVES - 21" DP x 36" L	-	-	-	-	OWNER	-
9201.08	1	E	EXISTING GREASE TRAP	-	-	-	-	OWNER	-
9201.16	1	E	EXISTING WORK TABLE F/ ABS & CONDIMENTS	-	-	-	-	OWNER	-
9203.02	1	E	EXISTING HEAT TREAT COMBINATION SHAKE/SUNDAE MACHINE	-	-	-	-	OWNER	-
9205.11	1	E	EXISTING FROZEN CARBONATED BEVERAGE	-	-	-	-	OWNER	-
9207.00	1	E	EXISTING BLENDER - COUNTERTOP - MCFLURRY	-	-	-	-	OWNER	-
9207.09	3	E	EXISTING BASE REFRIGERATOR	-	-	-	-	OWNER	-
9207.90	1	E	EXISTING CUP TUBES FOR HEAT TREAT MACHINE	-	-	-	-	OWNER	-
9215.00	3	E	EXISTING POS PC HARDWARE - FRONT COUNTER	-	-	-	-	OWNER	-
9215.98	4	E	EXISTING POS PC HARDWARE - D/T	-	-	-	-	OWNER	-
9216.00	7	E	EXISTING POS - VIDEO MONITOR	-	-	-	-	OWNER	-
9216.04	1	E	EXISTING ORB MONITOR (MINI)	-	-	-	-	OWNER	-
9216.05	1	E	EXISTING ORB MONITOR	-	-	-	-	OWNER	-
9216.07	1	E	EXISTING ORB SCANNER	-	-	-	-	OWNER	-
9218.00	4	E	EXISTING POS - CASH DRAWER	-	-	-	-	OWNER	-
9219.00	1	E	EXISTING POS - RECEIPT PRINTER	-	-	-	-	OWNER	-
9219.02	6	E	EXISTING POS - RECEIPT PRINTER	-	-	-	-	OWNER	-
9223.00	1	E	EXISTING WASHER	-	-	-	-	OWNER	-
9233.00	2	E	EXISTING WARMER	-	-	-	-	OWNER	-
9237.00	1	E	EXISTING PIE DISPLAY	-	-	-	-	OWNER	-
9700.00	2	E	EXISTING HAND SINK	-	-	-	-	OWNER	-
9700.02	1	E	EXISTING MOP SINK	-	-	-	-	OWNER	-
9700.07	1	E	WATER HEATER - GAS	-	-	-	-	OWNER	-
9700.09	4	E	EXISTING OEP BOX W/MOUNTING HARDWARE	-	-	-	-	OWNER	-
9700.10	2	E	EXISTING BULK OIL SYSTEM	-	-	-	-	OWNER	-